


THIS DOCUMENT, AND THE IDEAS AND DESIGNS INCORPORATED THEREIN, IS THE PROPERTY OF K4 ARCHITECTURE, L.L.C. AND IS NOT TO BE USED, IN WHOLE OR IN PART, FOR ANY OTHER PROJECT WITHOUT THE WRITTEN AUTHORIZATION OF K4 ARCHITECTURE, L.L.C. COPYRIGHT 2009. K4 ARCHITECTURE, L.L.C. ALL RIGHTS RESERVED.

File Location : G:\0010-9999\9610-9699\9611

Filename : 9681HV102.dwg Plot Date : Feb. 19, 2010 10:53am

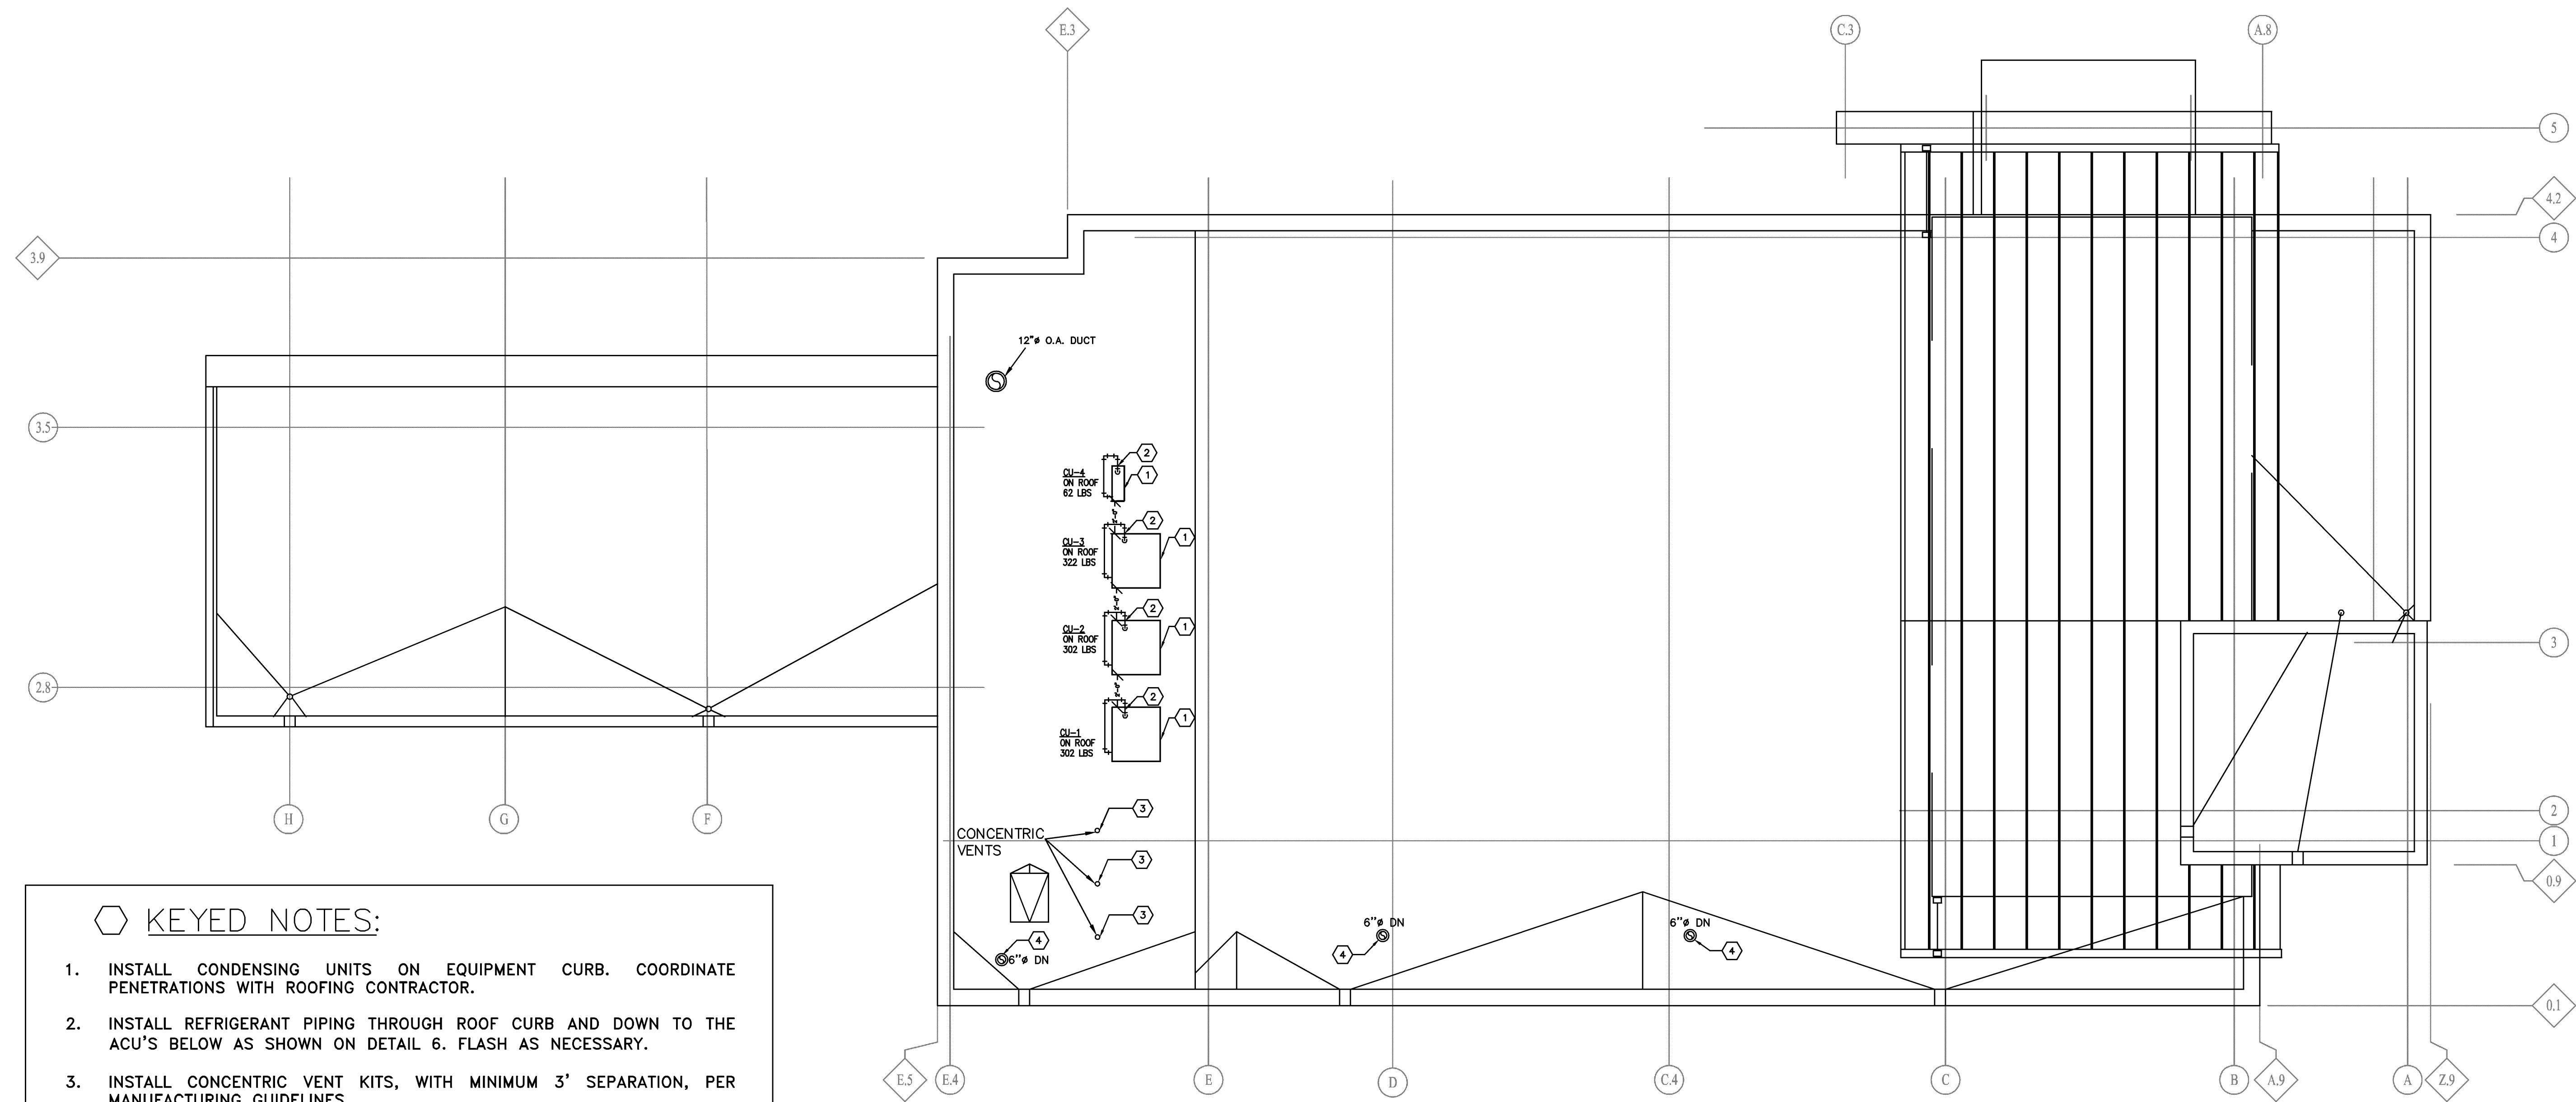

- KEYED NOTES:**
1. INSTALL CONDENSING UNITS ON EQUIPMENT CURB. COORDINATE PENETRATIONS WITH ROOFING CONTRACTOR.
  2. INSTALL REFRIGERANT PIPING THROUGH ROOF CURB AND DOWN TO THE ACU'S BELOW AS SHOWN ON DETAIL 6. FLASH AS NECESSARY.
  3. INSTALL CONCENTRIC VENT KITS, WITH MINIMUM 3' SEPARATION, PER MANUFACTURING GUIDELINES.
  4. INSTALL MANUFACTURING STANDARD EXHAUST CAP AS INDICATED.

- GENERAL NOTES:**
- A. PROVIDE ALL LABOR, MATERIAL, AND EQUIPMENT NECESSARY TO COMPLETELY FURNISH, INSTALL, AND PLACE INTO OPERATION, ALL SYSTEMS SHOWN ON THE DRAWINGS AND DELINEATED IN THE SPECIFICATIONS IN ACCORDANCE WITH ALL STATE AND LOCAL CODES AND ORDINANCES. REPORT ANY KNOWN DISCREPANCIES TO THE ARCHITECT/ENGINEER PRIOR TO INSTALLATION.
  - B. DO NOT SCALE DRAWINGS; REFER TO ARCHITECTURAL DRAWINGS FOR DIMENSIONED LOCATIONS OF WALLS, DOORS, WINDOWS, AND CABINETS.
  - C. COORDINATE LOCATIONS AND ORIENTATION OF ROOF MOUNTED EQUIPMENT WITH ARCHITECTURAL AND STRUCTURAL DRAWINGS.
  - D. INSTALL ALL EQUIPMENT WITH CODE REQUIRED AND MANUFACTURER RECOMMENDED MINIMUM CLEARANCES FOR SERVICE, ACCESS, AND FIRE PROTECTION.
  - E. MAINTAIN A MINIMUM OF 10 FEET BETWEEN ALL OUTSIDE AIR INTAKES AND ALL EXHAUST, VENT, AND FLUE OUTLETS.

**ROOF WORK:**

COORDINATE ALL ROOF WORK WITH FIRST FINANCIAL BANK. VERIFY WHETHER ROOF WORK IS TO BE DONE BY ROOFING CONTRACTOR OR MECHANICAL CONTRACTOR TO AVOID ANY ROOF WARRANTY ISSUES. ALL COSTS FOR ROOF WORK SHALL BE INCLUDED IN THE MECHANICAL CONTRACTOR'S BID.

**K4 ARCHITECTURE, LLC**  
 555 Gest Street  
 Cincinnati, Ohio 45203  
 Tel: (513) 455-5005  
 Fax: (513) 455-5008  
 Webpage: www.k4places.com  
 Email: info@k4places.com

PROPOSED BANKING CENTER FOR:

**first** financial bank

Shelbyville Branch  
 1850 MARKETPLACE Blvd.  
 SHELBYVILLE, INDIANA 46176

REVISIONS / SUBMISSIONS		
NO.	DESCRIPTION	DATE
1	PERMIT AND BID	02/22/10

**KOHRS, LONNEMANN, HEIL**  
 ENGINEERS, P.S.C.  
 MECHANICAL/ELECTRICAL ENGINEERS  
 WWW.KLHEILERS.COM

1535 ALEXANDRIA PARK, STE. 1  
 CINCINNATI, OHIO 45240  
 513-334-9183  
 513-334-9185  
 513-334-9186

104 BROWN STREET  
 SHELBYVILLE, IN 46176  
 317-326-0700

H.V.A.C.  
 ROOF PLAN

Drawn By: KTW  
 Scale: AS NOTED  
 Job No.: 09-2109

**HV102**