
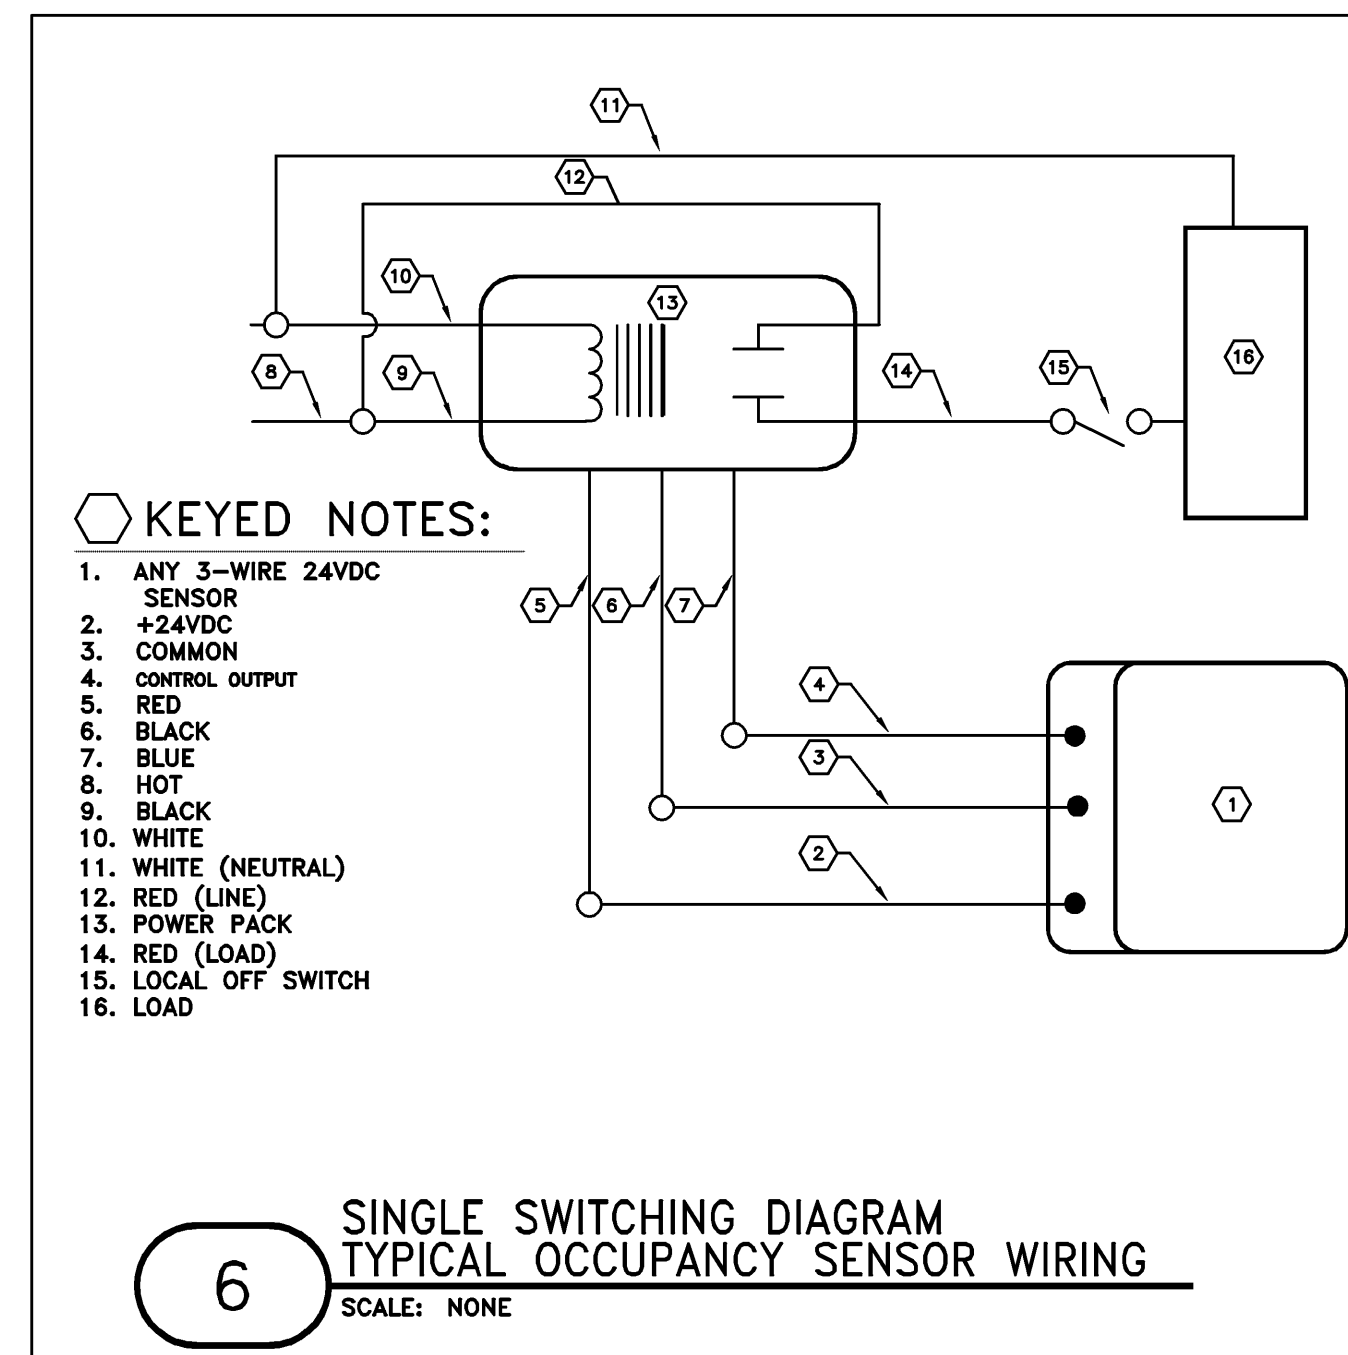
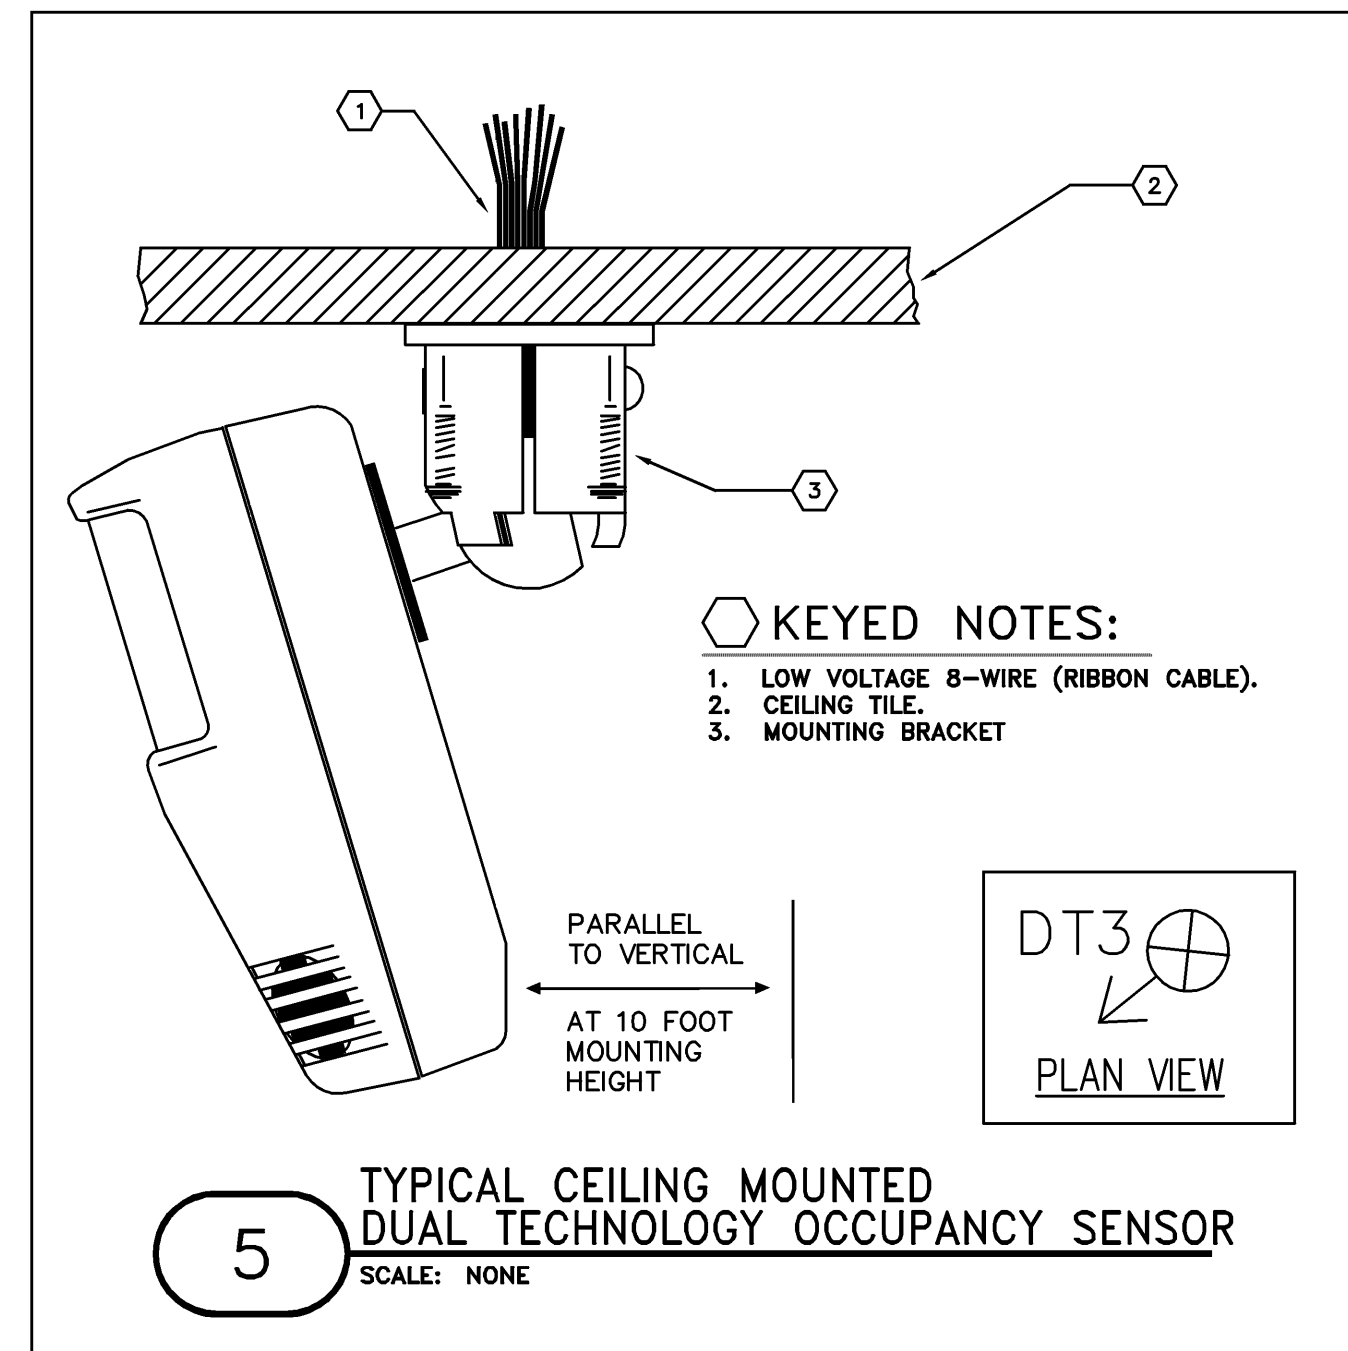
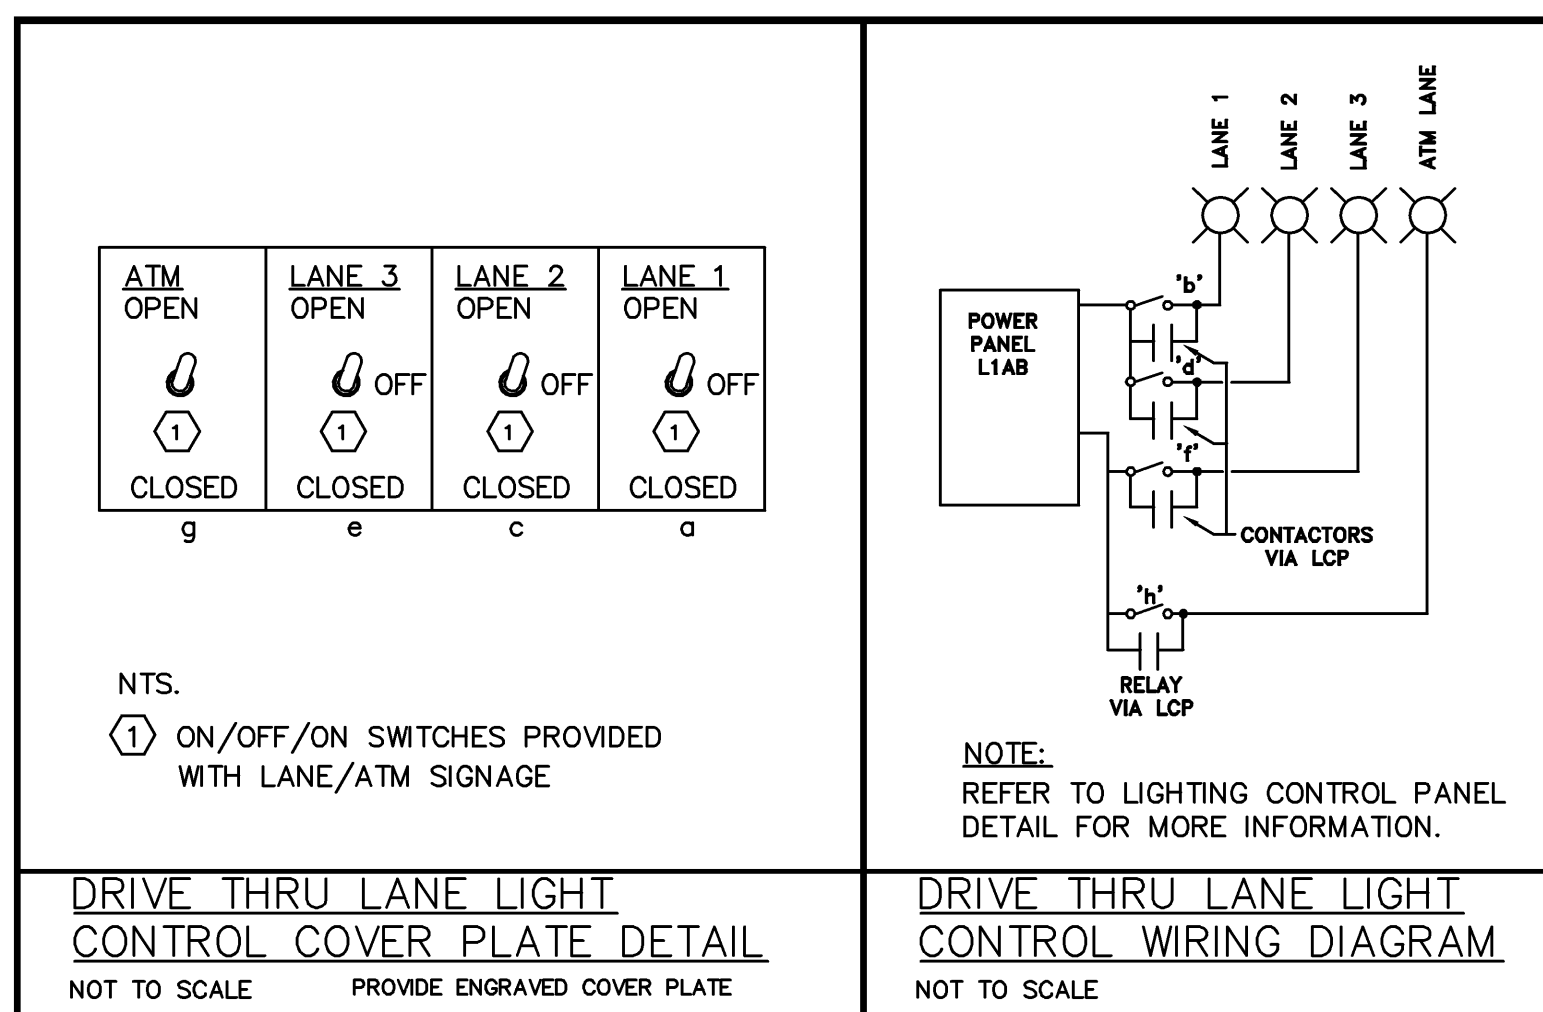
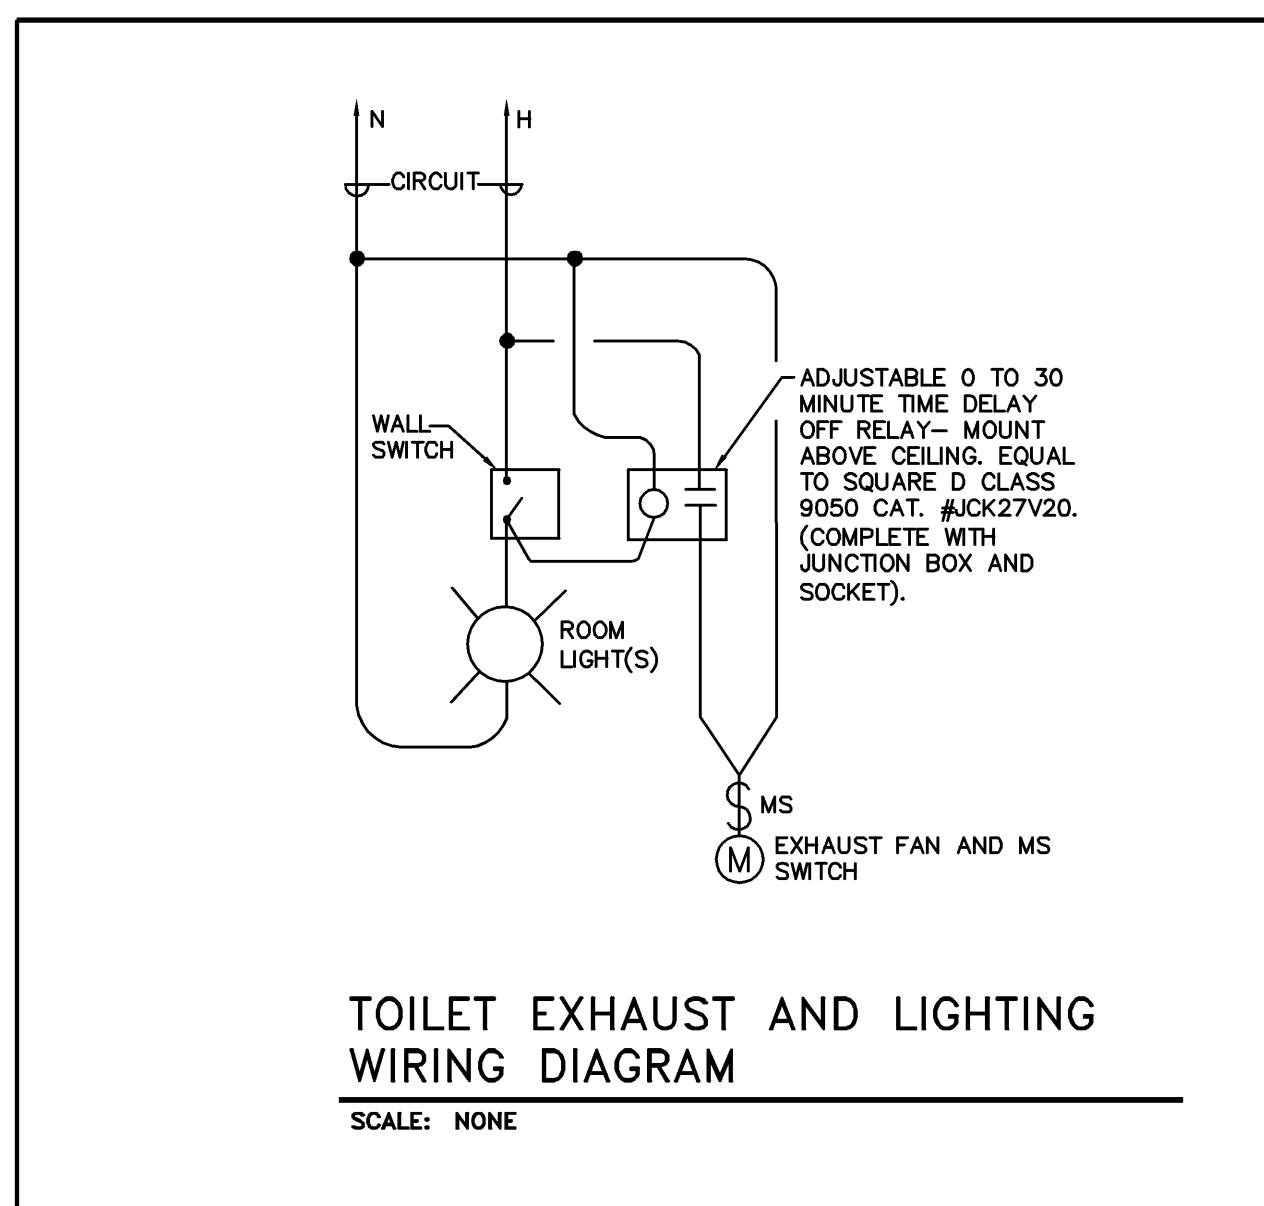
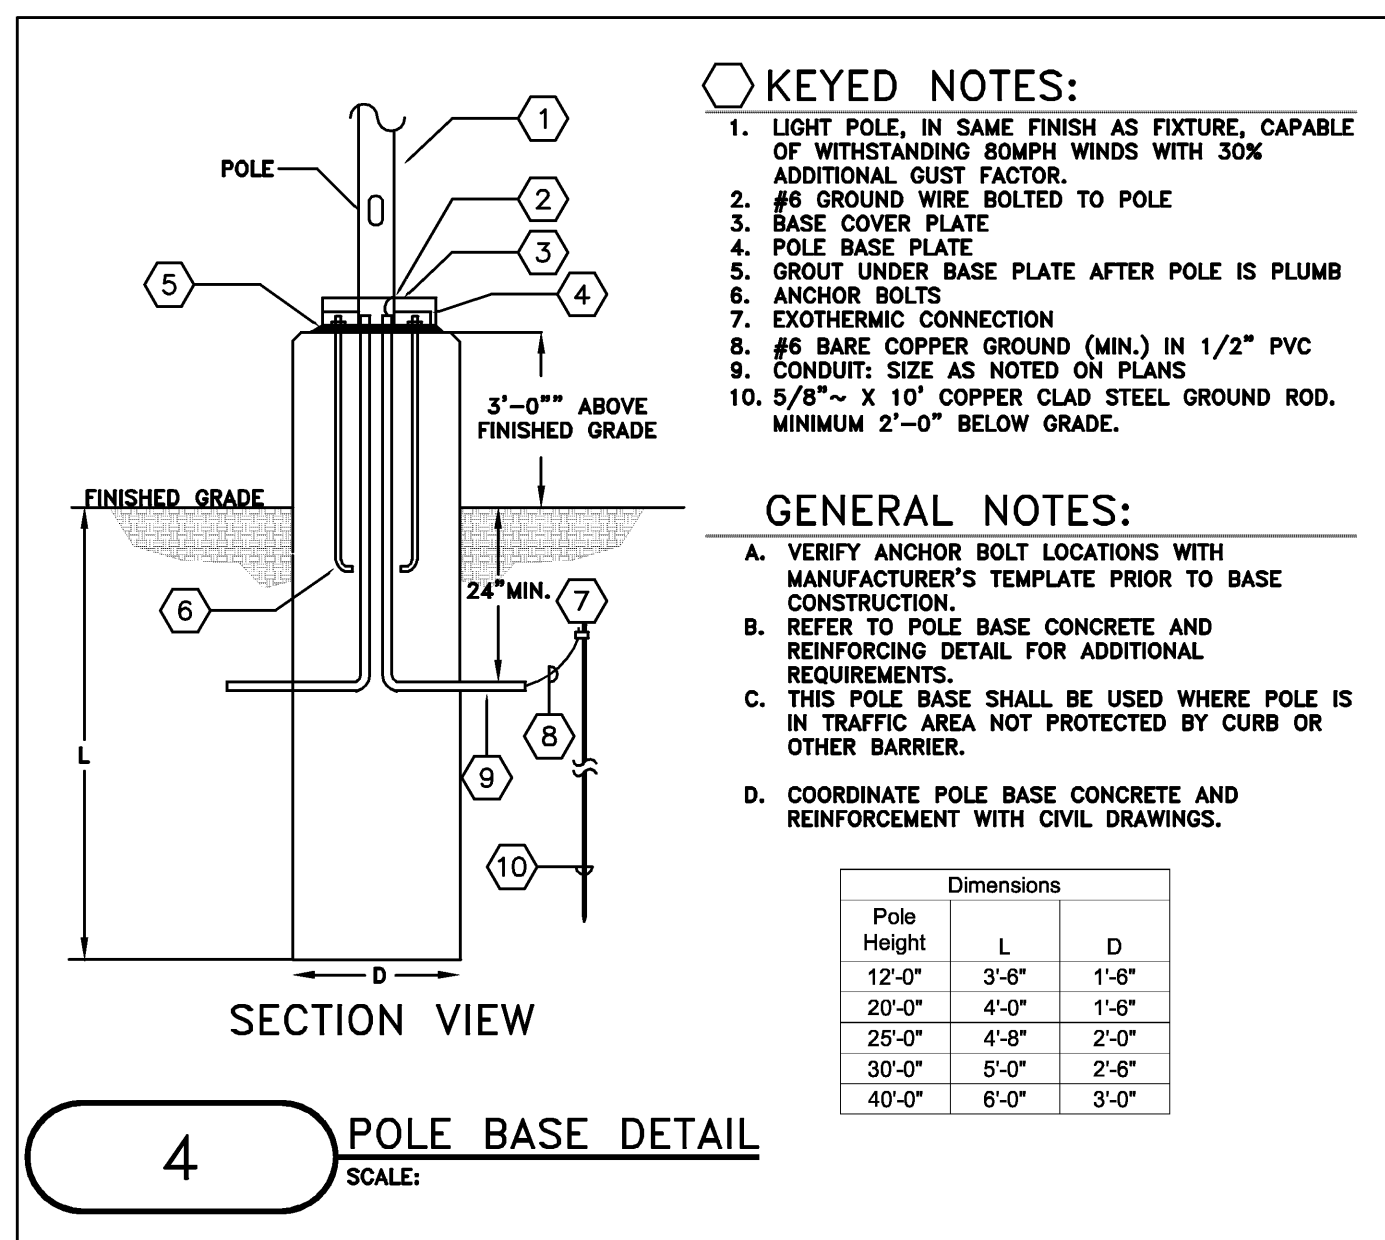
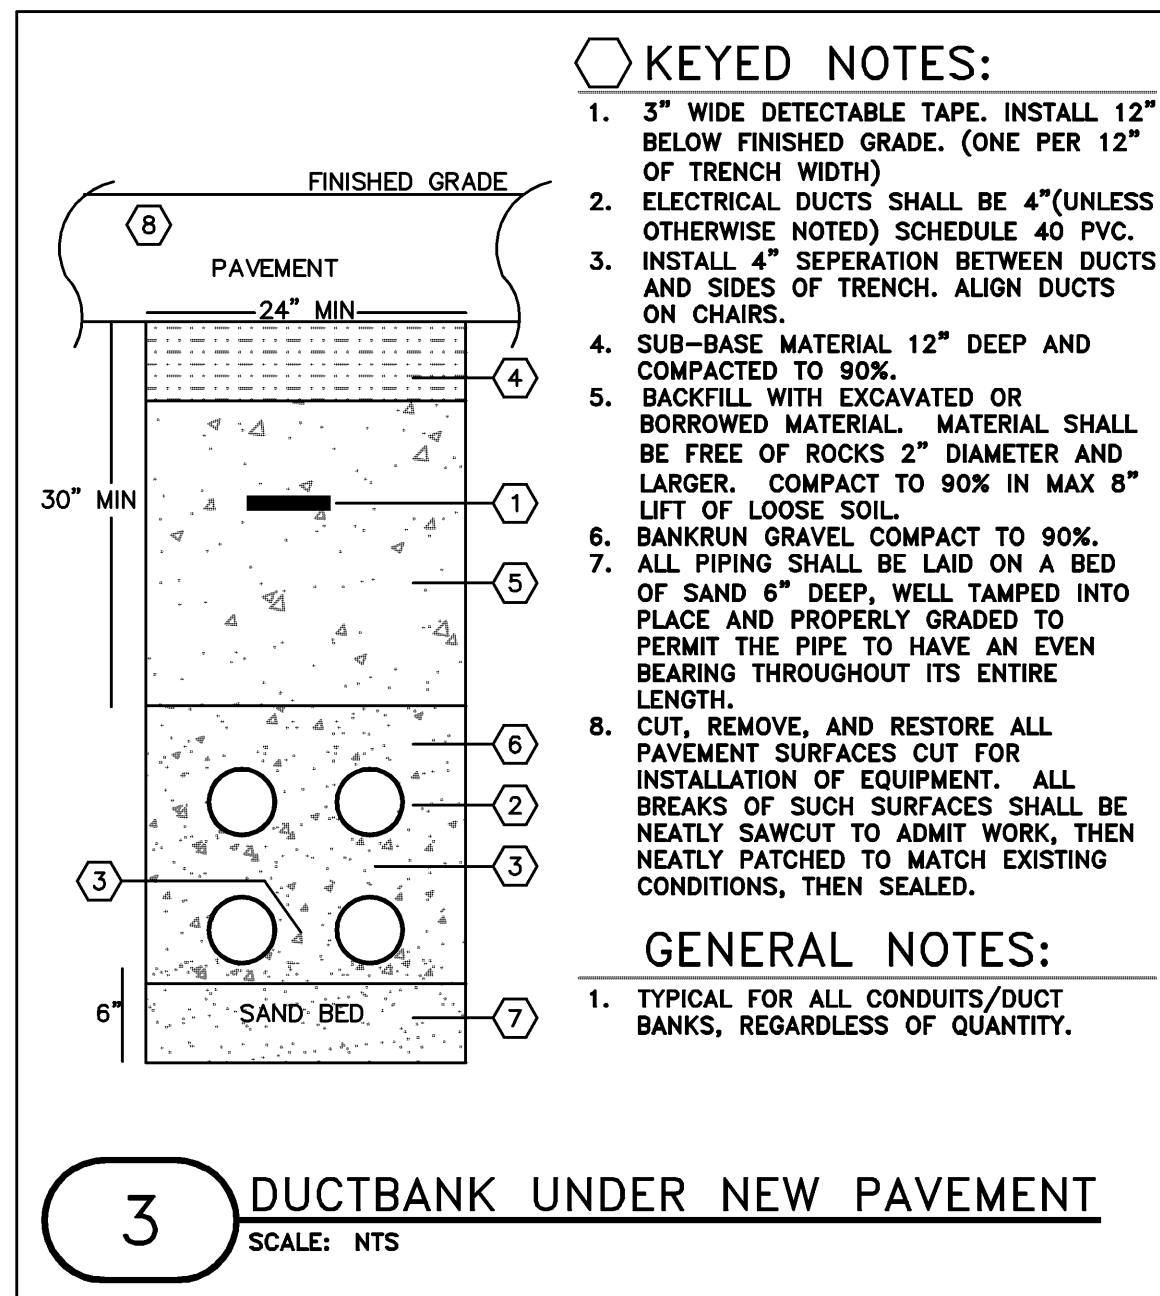
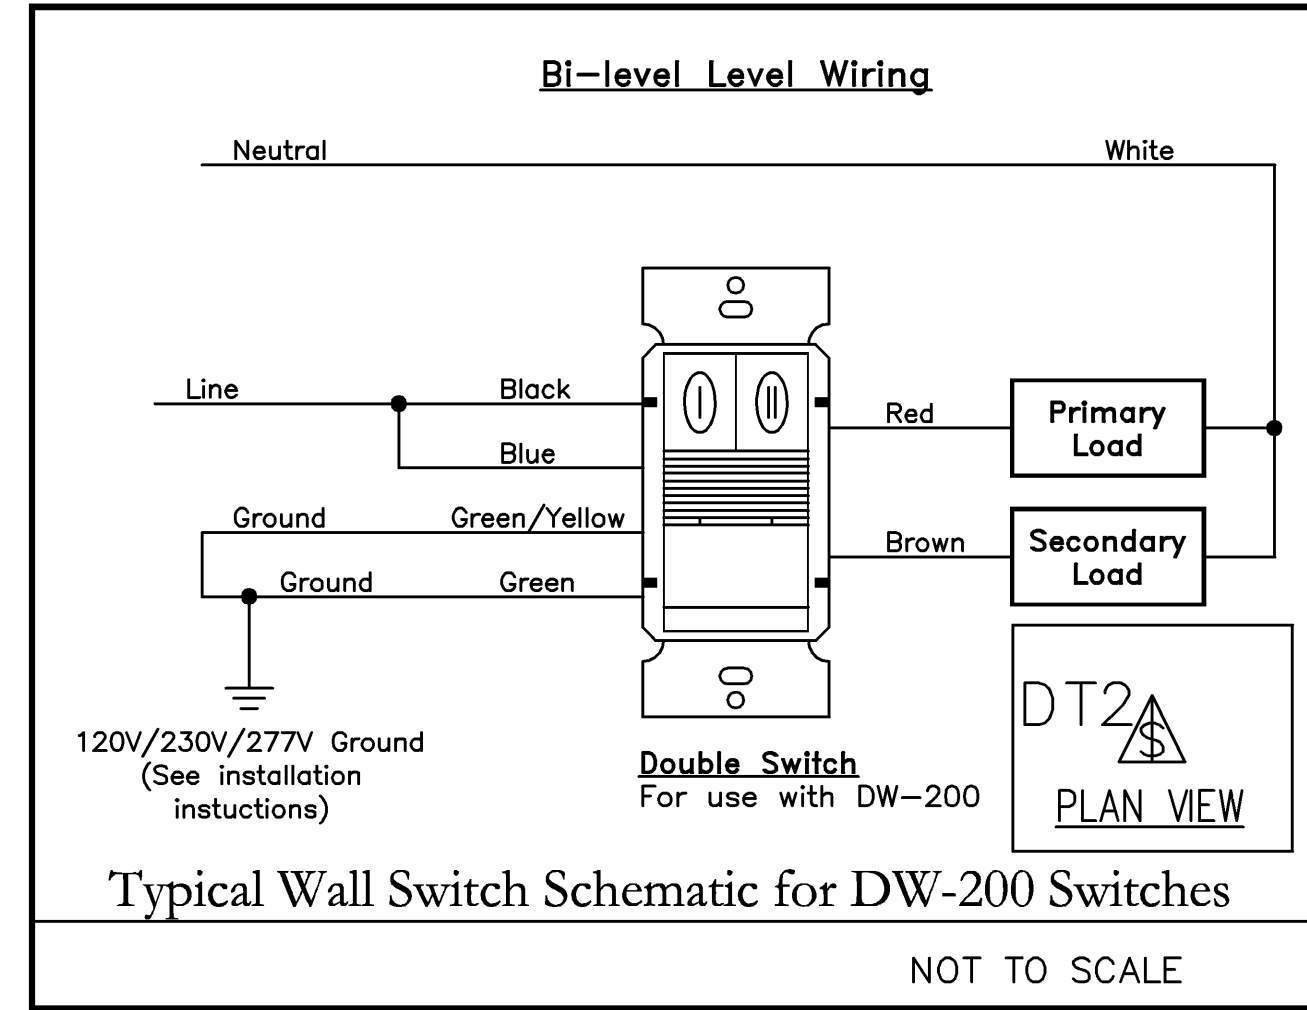
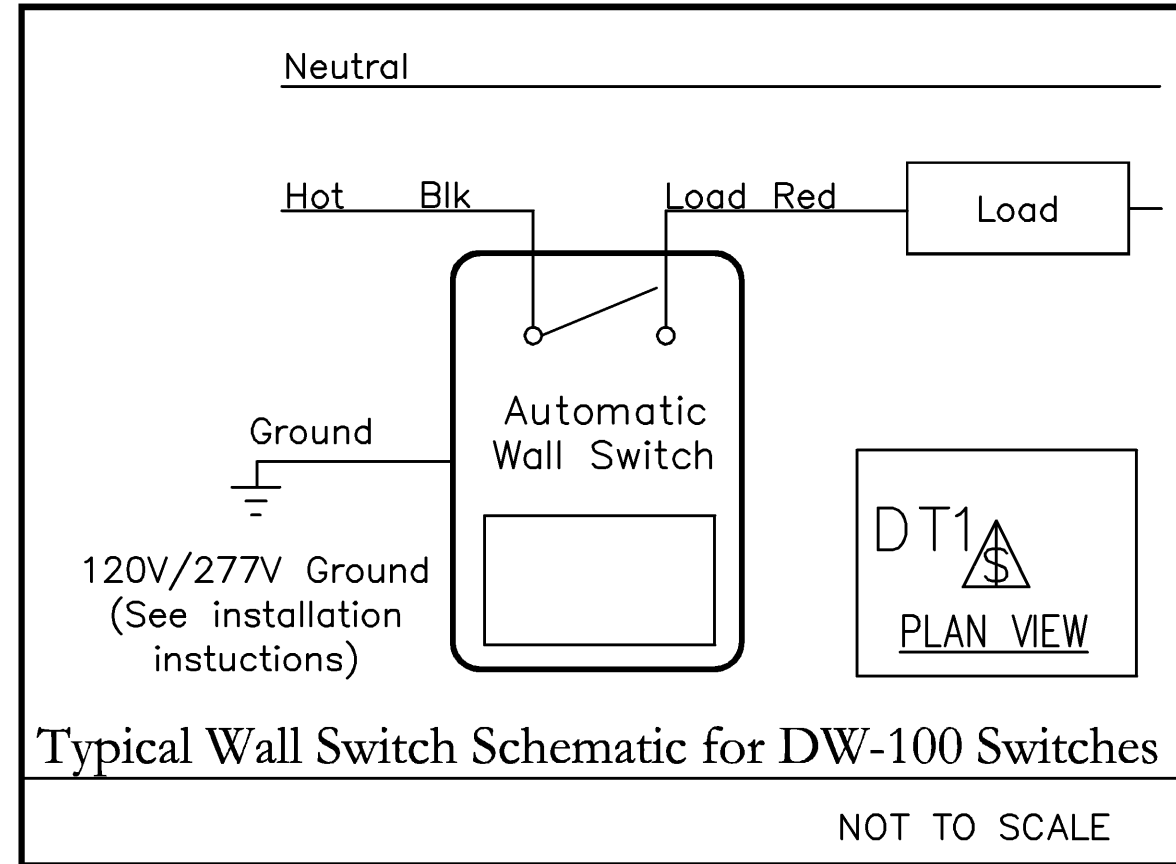
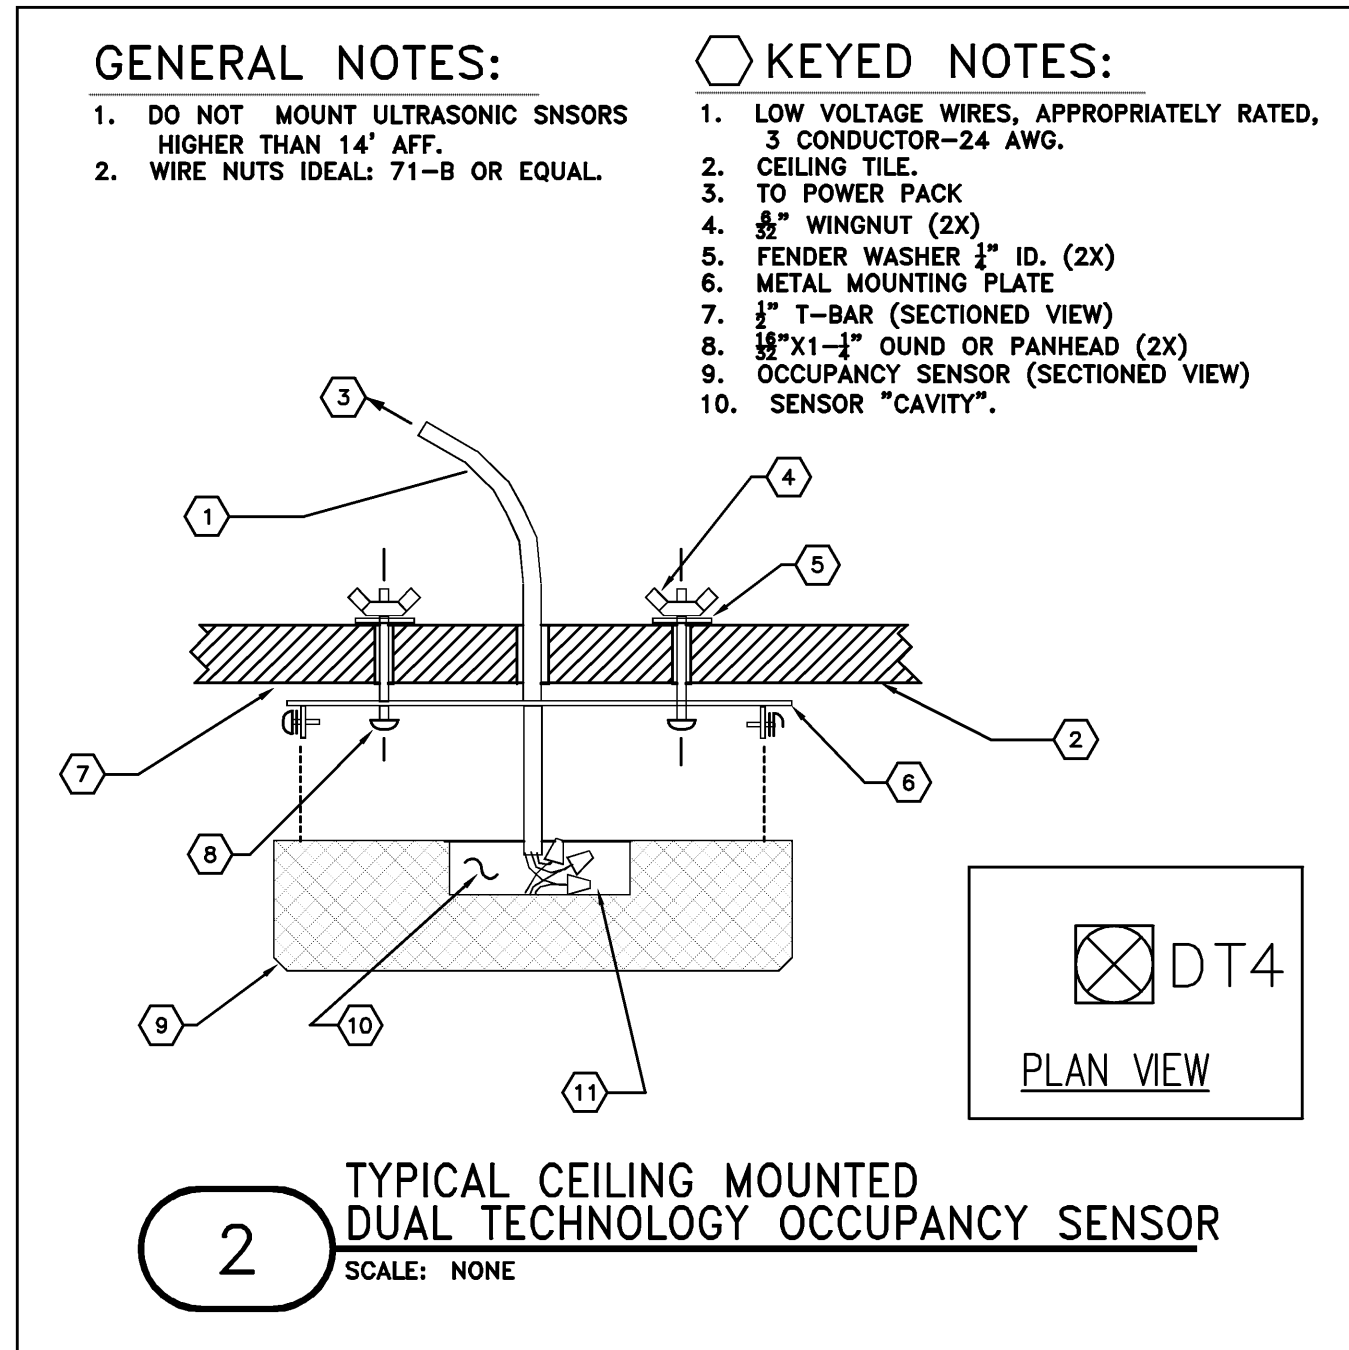


THIS DOCUMENT, AND THE IDEAS AND DESIGNS INCORPORATED HEREIN, IS THE PROPERTY OF K4 ARCHITECTURE, L.L.C. AND IS NOT TO BE USED, IN WHOLE OR IN PART, FOR ANY OTHER PROJECT WITHOUT THE WRITTEN AUTHORIZATION OF K4 ARCHITECTURE, L.L.C. COPYRIGHT 2009. K4 ARCHITECTURE, L.L.C. ALL RIGHTS RESERVED.

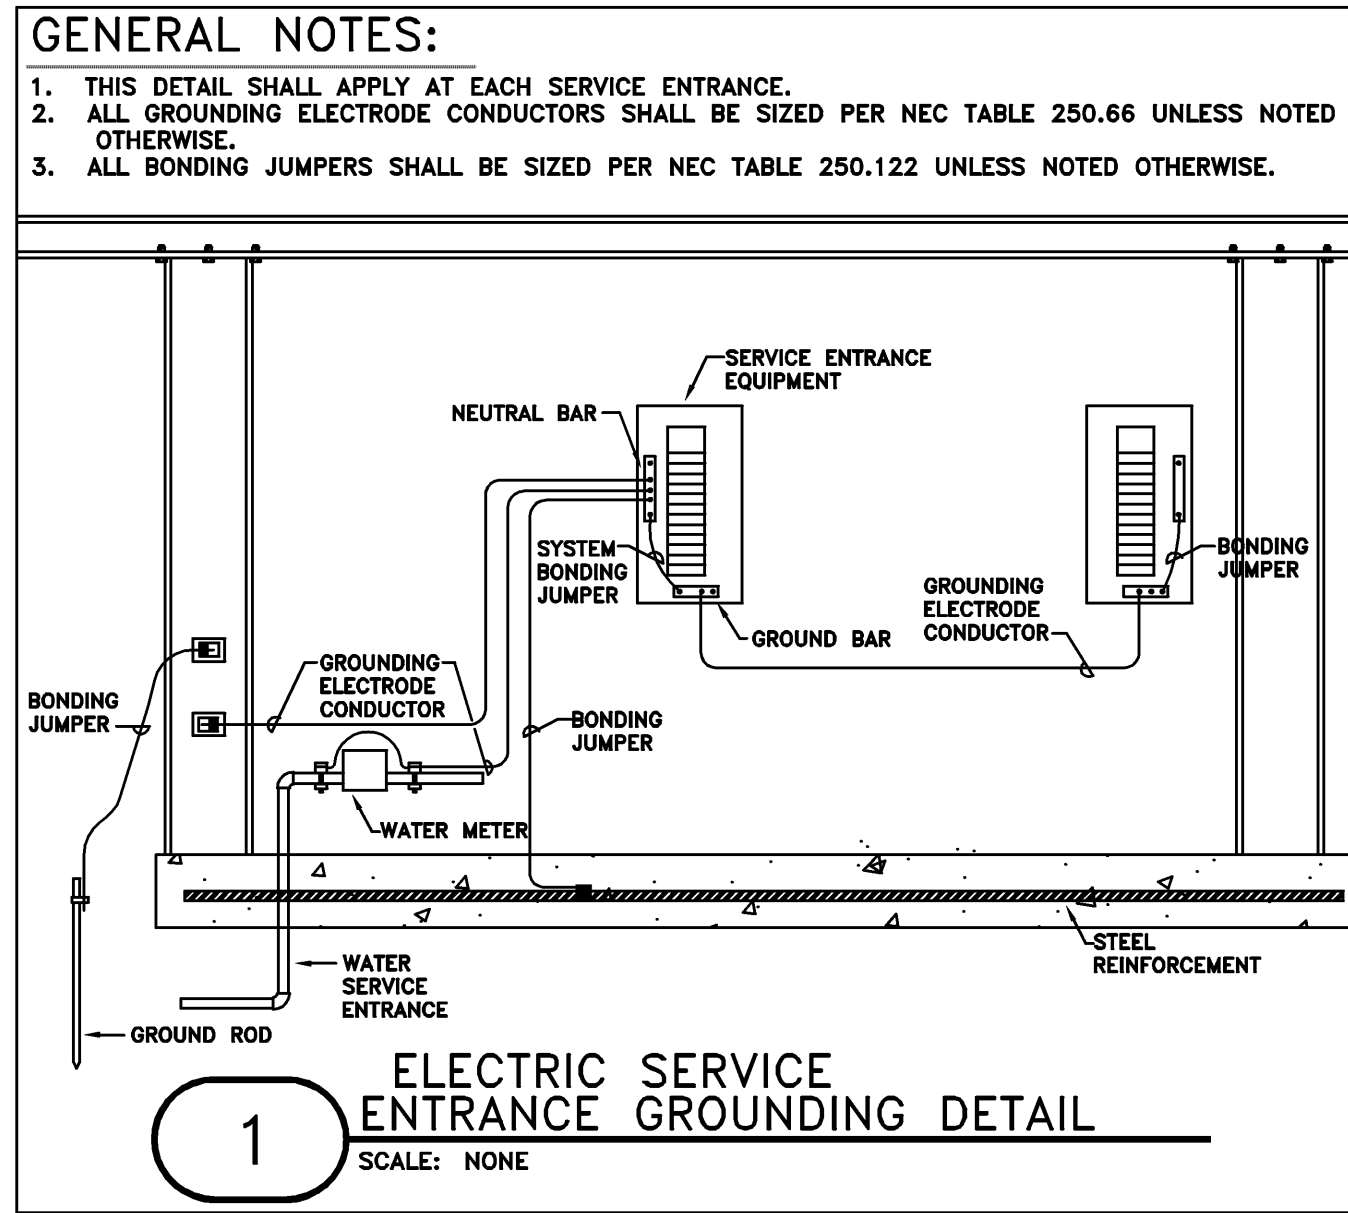

K4
ARCHITECTURE, L.L.C.

655 Geel Street
Cincinnati, Ohio 45203
Tel: (513) 455-5005
Fax: (513) 455-5008
Webpage: www.k4places.com
Email: info@k4places.com

PROPOSED BANKING CENTER FOR:

Shelbyville Branch
1850 MARKETPLACE Blvd.
SHELBYVILLE, INDIANA 46176

first
first financial bank

REVISIONS / SUBMISSIONS		
NO.	DESCRIPTION	DATE
1	PERMIT AND BID	02/22/10

KOHRS, LONEMAN, HELM
MECHANICAL ELECTRICAL ENGINEERS
WWW.KLEENERS.COM

1258 ALEXANDRIA PIKE, STE. 11
1410 BROWN STREET, SUITE 100
SAVING, OHIO 44867
800-442-4600

ELECTRICAL POWER DETAILS

Drawn By: SCR
Scale: AS NOTED
Job No.: 09-2109

E201

ELECTRICAL POWER - DETAILS
SCALE: NOT TO SCALE