


- SECOND FLOOR PLAN KEY NOTES:**
 (APPLIES TO THIS SHEET ONLY)
- 1) CONNECT NEW DEVICES IN THIS ROOM TO POWER CIRCUIT IN ROOM SERVING THIS AREA
 - 2) CONNECT NEW DEVICES IN THIS ROOM TO NEW HOME RUN IN EXISTING PANEL SERVING THIS AREA
 - 3) NEW/EXIST/RELO POWER & DATA DROP TO RELOC ELECTRICAL
 - 4) NEW DEVICE BELOW EXIST. RADIATOR PAINT CONDUIT BLACK

SECOND FLOOR ELECTRICAL POWER PLAN LEGEND:

- ⊕ DUPLEX RECEPTACLE 115V
- ⊕ WEATHER PROOF DUPLEX RECEPTACLE FEED THRU GFI
- ◄ TELEPHONE, COMPUTER OR DATA W/ 3/4" CONDUIT STUB ABOVE CEILING
- ⊕ QUADRAPLEX RECEPTACLE 115V
- ⊙ JUNCTION BOX (VOLTAGE AS NOTED)



EX = EXISTING FIXTURE, RE = RELOCATED FIXTURE, NEW = NEW FIXTURE

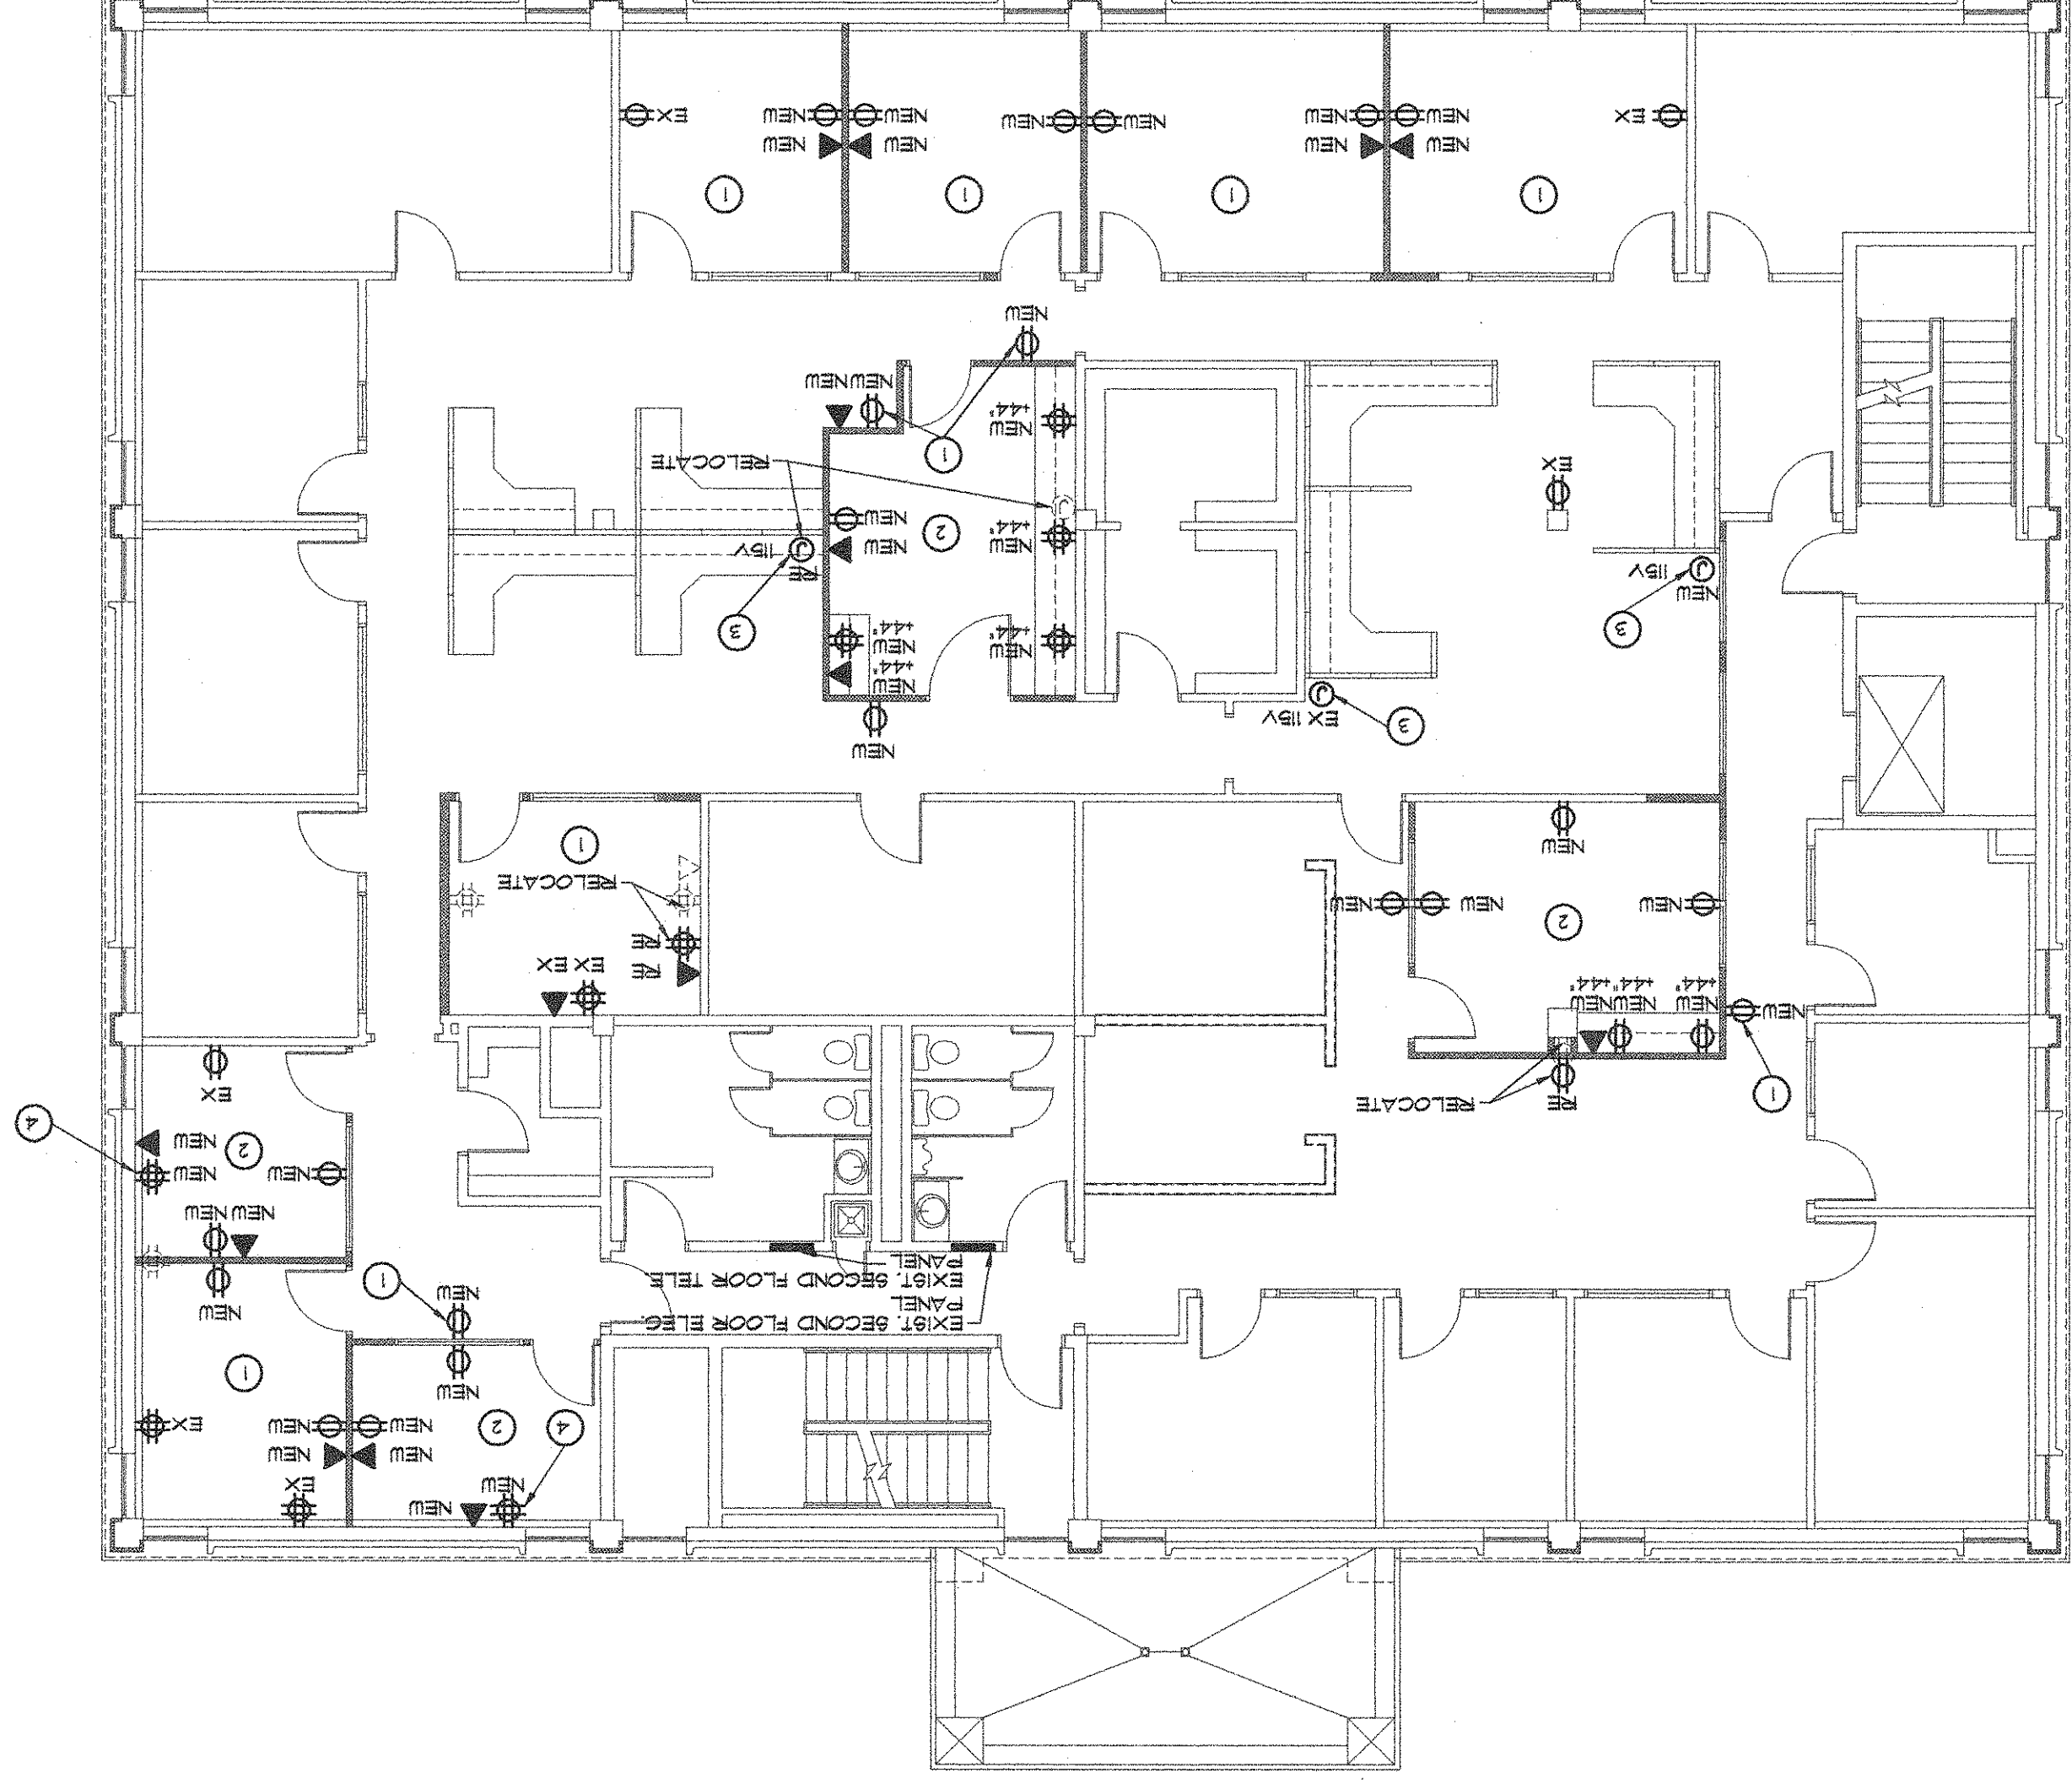

SECOND FLOOR ELECTRICAL POWER PLAN

PLAN NORTH

SCALE: 1/8" = 1'-0"

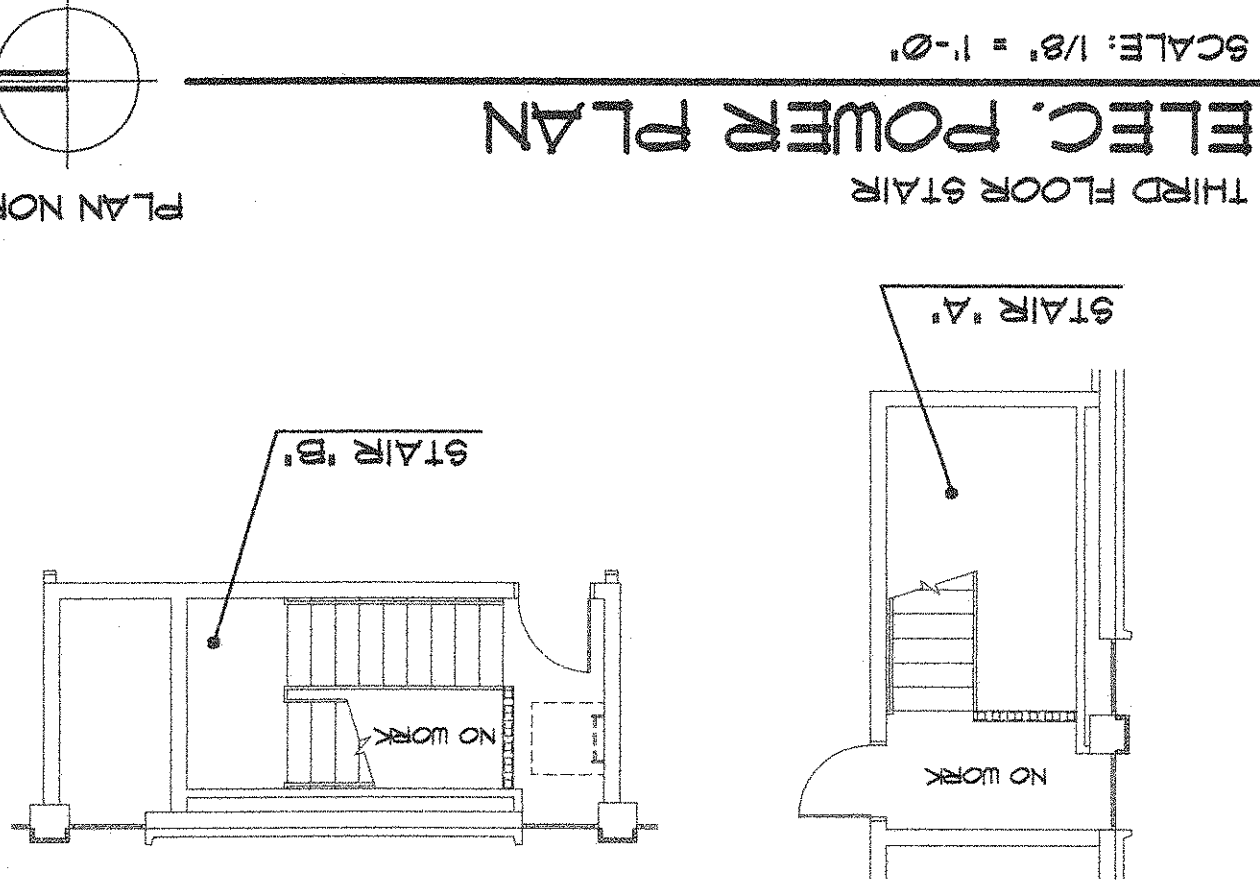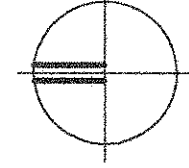

THIRD FLOOR STAIR ELEC. POWER PLAN

SCALE: 1/8" = 1'-0"

PLAN NORTH


SECOND FLOOR PLAN KEY NOTES:

- 1) CONNECT NEW DEVICES IN THIS ROOM TO POWER CIRCUIT IN ROOM SERVING THIS AREA
- 2) CONNECT NEW DEVICES IN THIS ROOM TO NEW HOME RUN IN EXISTING PANEL SERVING THIS AREA
- 3) NEW/EXIST/RELO POWER & DATA DROP TO RELOC ELECTRICAL
- 4) NEW DEVICE BELOW EXIST. RADIATOR PAINT CONDUIT BLACK

SECOND FLOOR ELECTRICAL POWER PLAN LEGEND:

- ⊕ DUPLEX RECEPTACLE 115V
- ⊕ WEATHER PROOF DUPLEX RECEPTACLE FEED THRU GFI
- ◄ TELEPHONE, COMPUTER OR DATA W/ 3/4" CONDUIT STUB ABOVE CEILING
- ⊕ QUADRAPLEX RECEPTACLE 115V
- ⊙ JUNCTION BOX (VOLTAGE AS NOTED)


EX = EXISTING FIXTURE, RE = RELOCATED FIXTURE, NEW = NEW FIXTURE

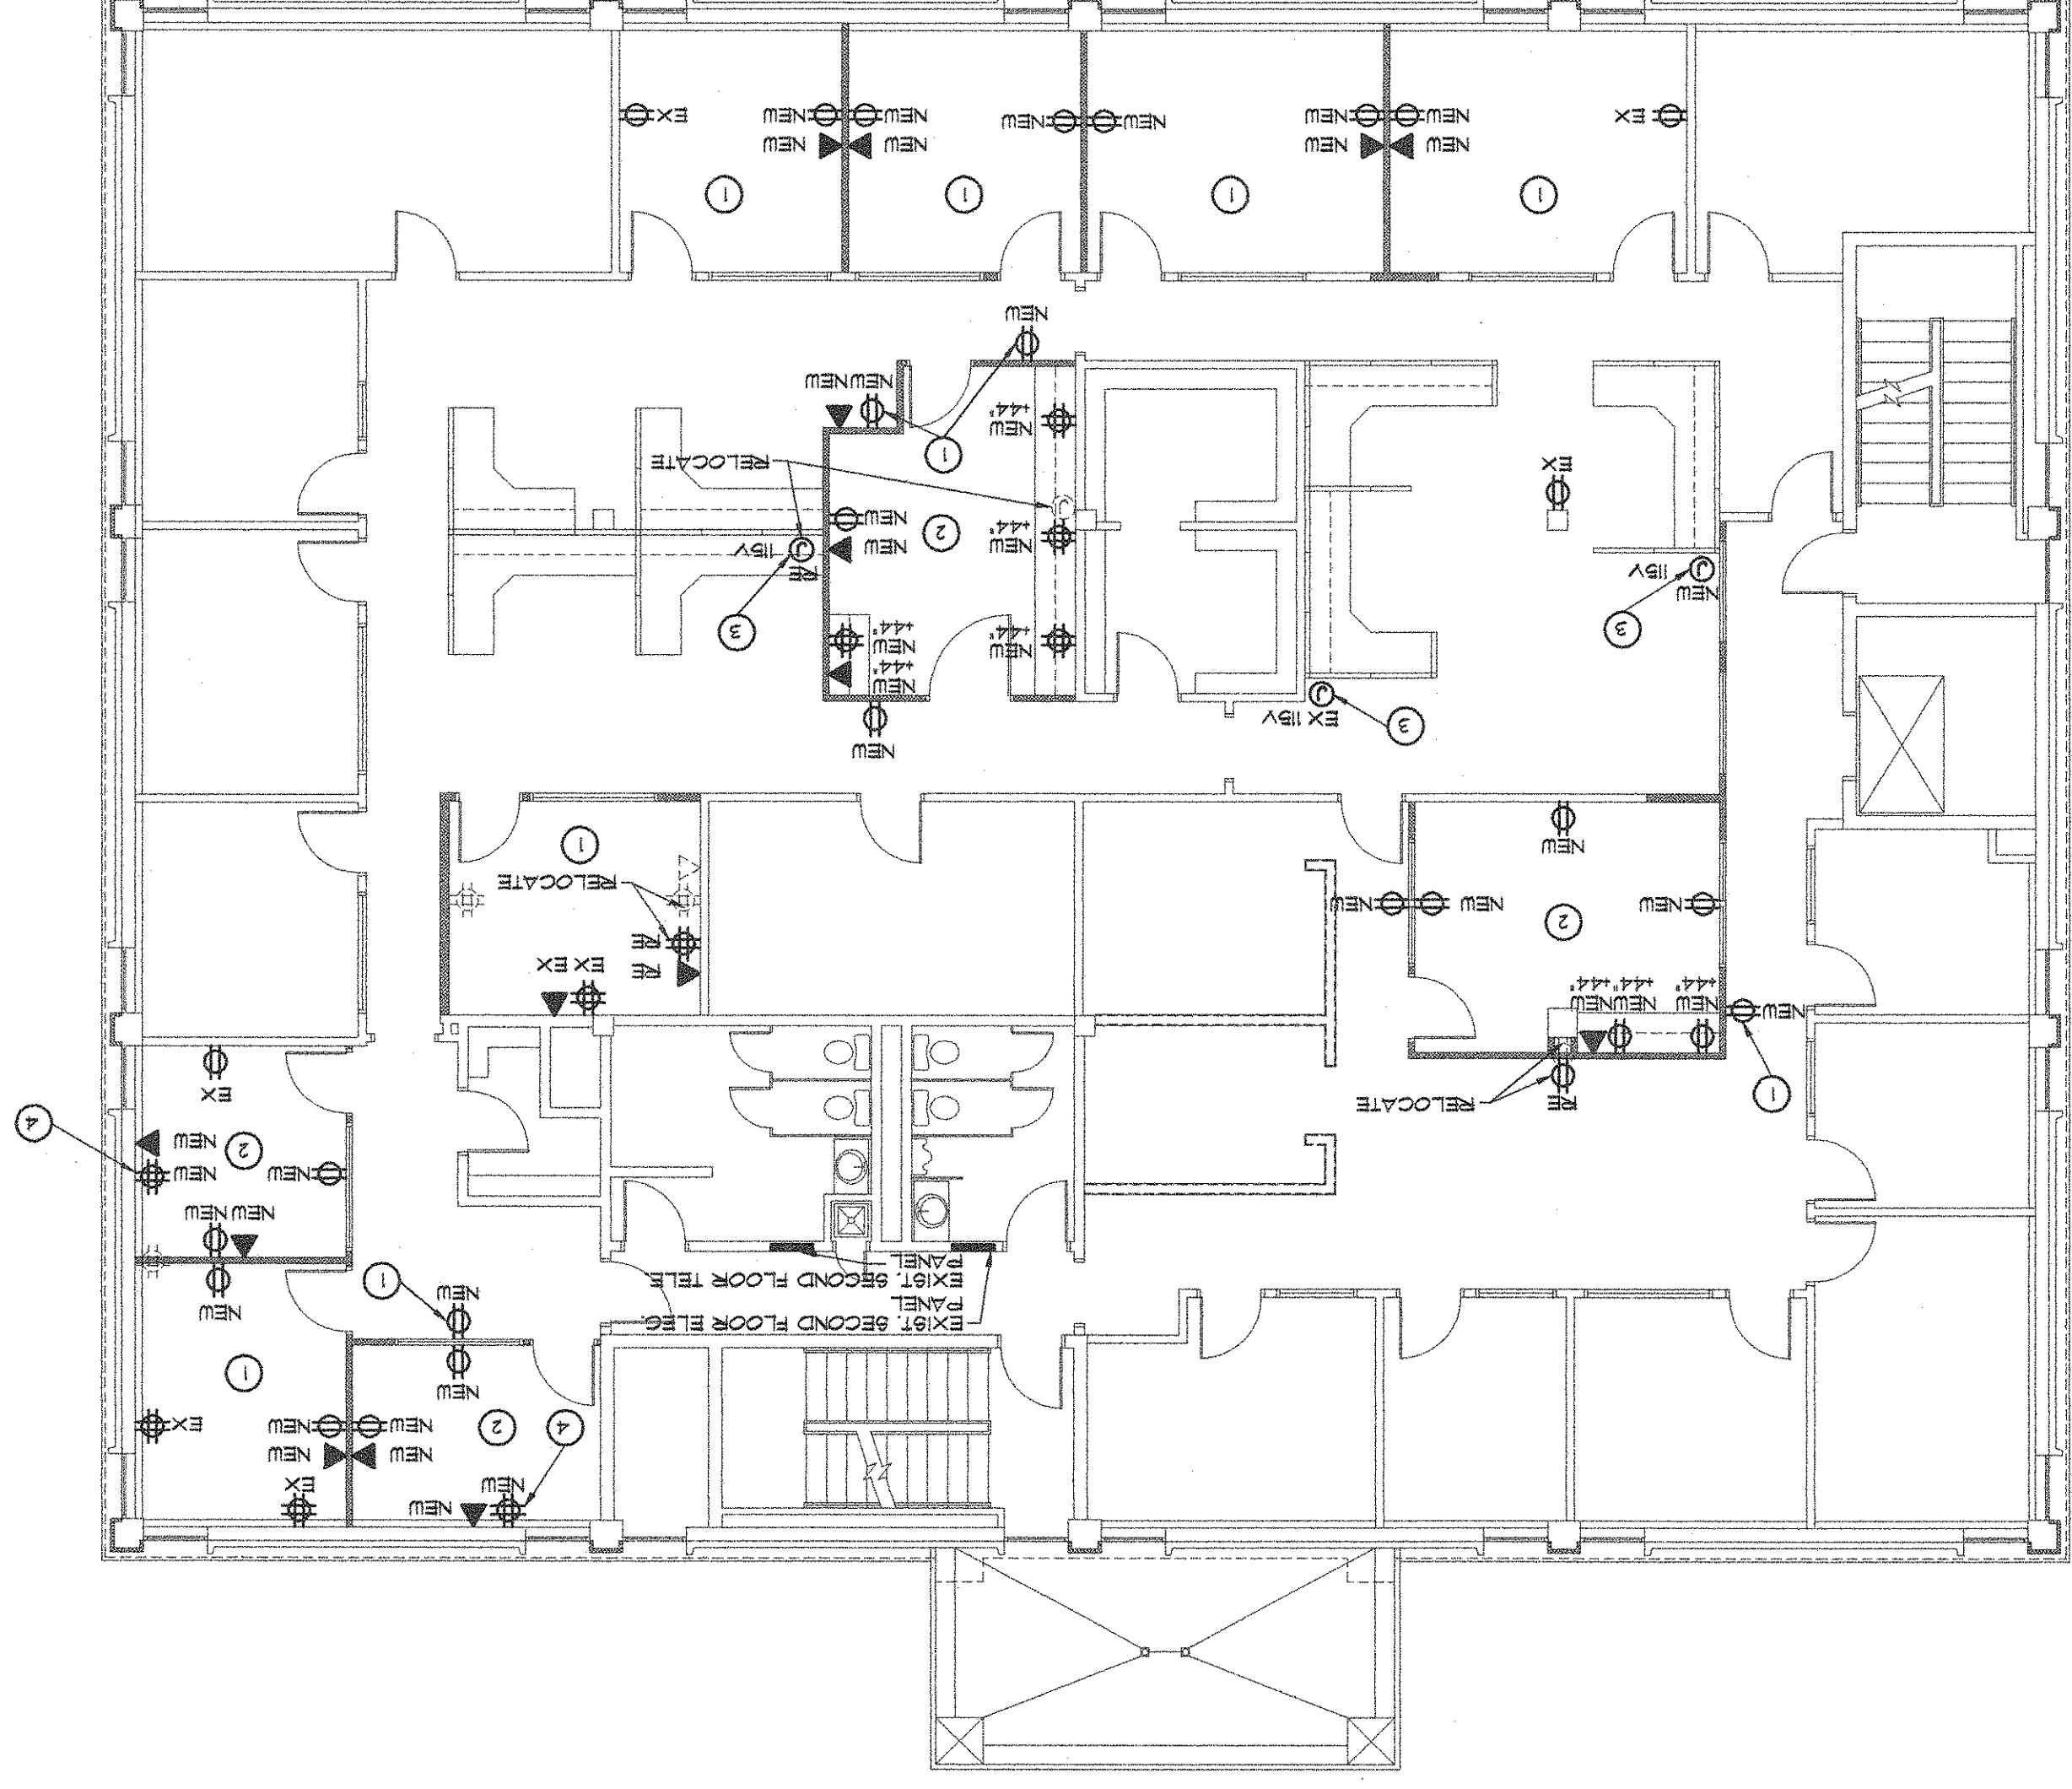

SECOND FLOOR ELECTRICAL POWER PLAN

PLAN NORTH

SCALE: 1/8" = 1'-0"

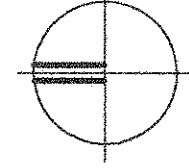

PROJECT NO.:

0817

EXTERIOR & INTERIOR RENOVATIONS FOR:

**THE SALVATION ARMY
INDIANA DIVISIONAL HEADQUARTERS**


3100 NORTH MERIDIAN STREET
INDIANAPOLIS, INDIANA 46208

ISSUE DATE:

DECEMBER 3, 2008

REVISIONS:

CERTIFICATION

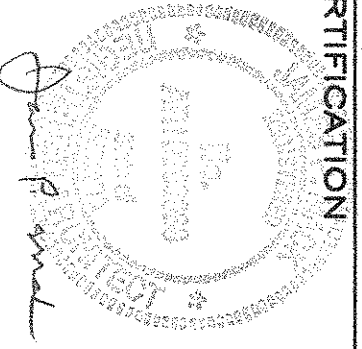

E12

SHEET NO.

Mock Architects

Mock Architects, P.C.
5920 North Keystone Avenue
Indianapolis, Indiana 46220
Phone: (317) 251-2468
Fax: (317) 251-2469
Email: mockarchitects@scgglobal.net