

SECOND FLOOR MECHANICAL PLAN

SCALE: 1/8" = 1'-0"



M12 SHEET NO.

CERTIFICATION:



ISSUE DATE:
DECEMBER 31, 2008

REVISIONS:

EXTERIOR & INTERIOR RENOVATIONS FOR:



**THE SALVATION ARMY
INDIANA DIVISIONAL HEADQUARTERS**

3100 NORTH MERIDIAN STREET
INDIANAPOLIS, INDIANA 46208

PROJECT NO:
0917

THIRD FLOOR STAIR MECHANICAL PLAN

SCALE: 1/8" = 1'-0"

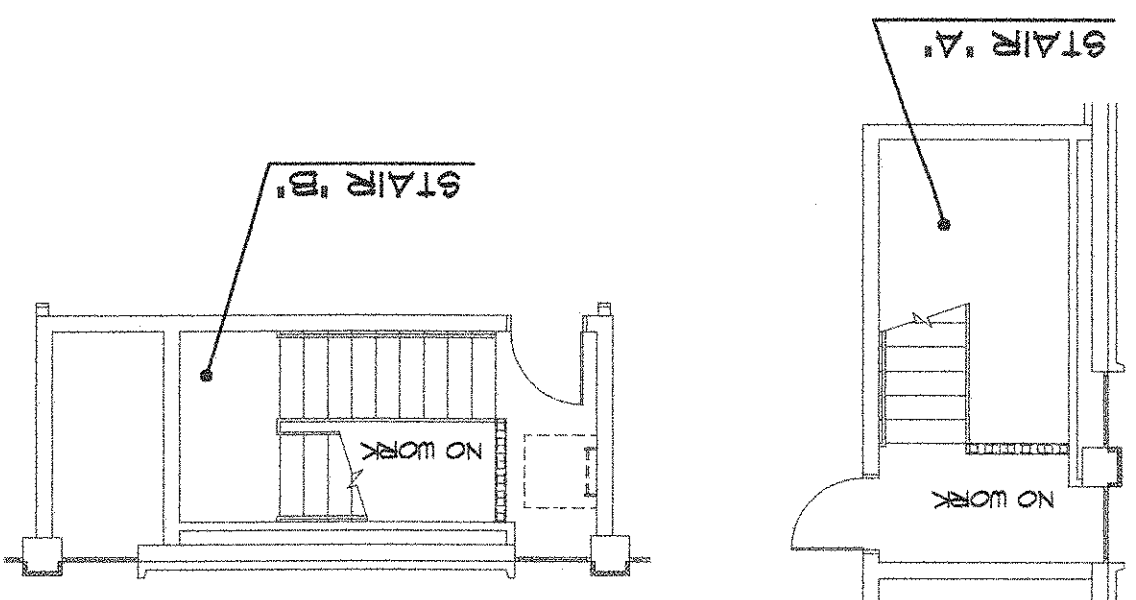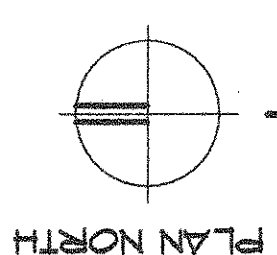

SECOND FLOOR MECHANICAL PLAN LEGEND:
EX = EXISTING FIXTURE, RE = RELOCATED FIXTURE, NEW = NEW FIXTURE

- HVAC SUPPLY AIR DIFFUSER
- HVAC RETURN AIR GRILLE

Mack Architects

Mack Architects, P.C.
3920 North Keystone Avenue
Indianapolis, Indiana 46220
Phone: (317) 251-2468 Fax: (317) 251-2469
Email: mackarchitects@sbcglobal.net