


- GENERAL HYAC NOTES:** (APPLIES TO ALL SHEETS)
1. All systems shall be installed per applicable state, local, NFPA codes.
 2. Refer to architectural drawings for exact ceiling systems and room layouts.
 3. Prior to commencing work mechanical contractor shall verify all existing site utilities as it pertains to his work for location.
 4. All ductwork shall be galvanized metal installed per SMACNA standards. Turning vanes shall be provided on all elbows larger than 12" x 12". All branch takeoffs on return and supply ducts shall have single blade volume damper.
 5. Maximum flex duct length to grilles and diffusers shall be 6' unless otherwise indicated.

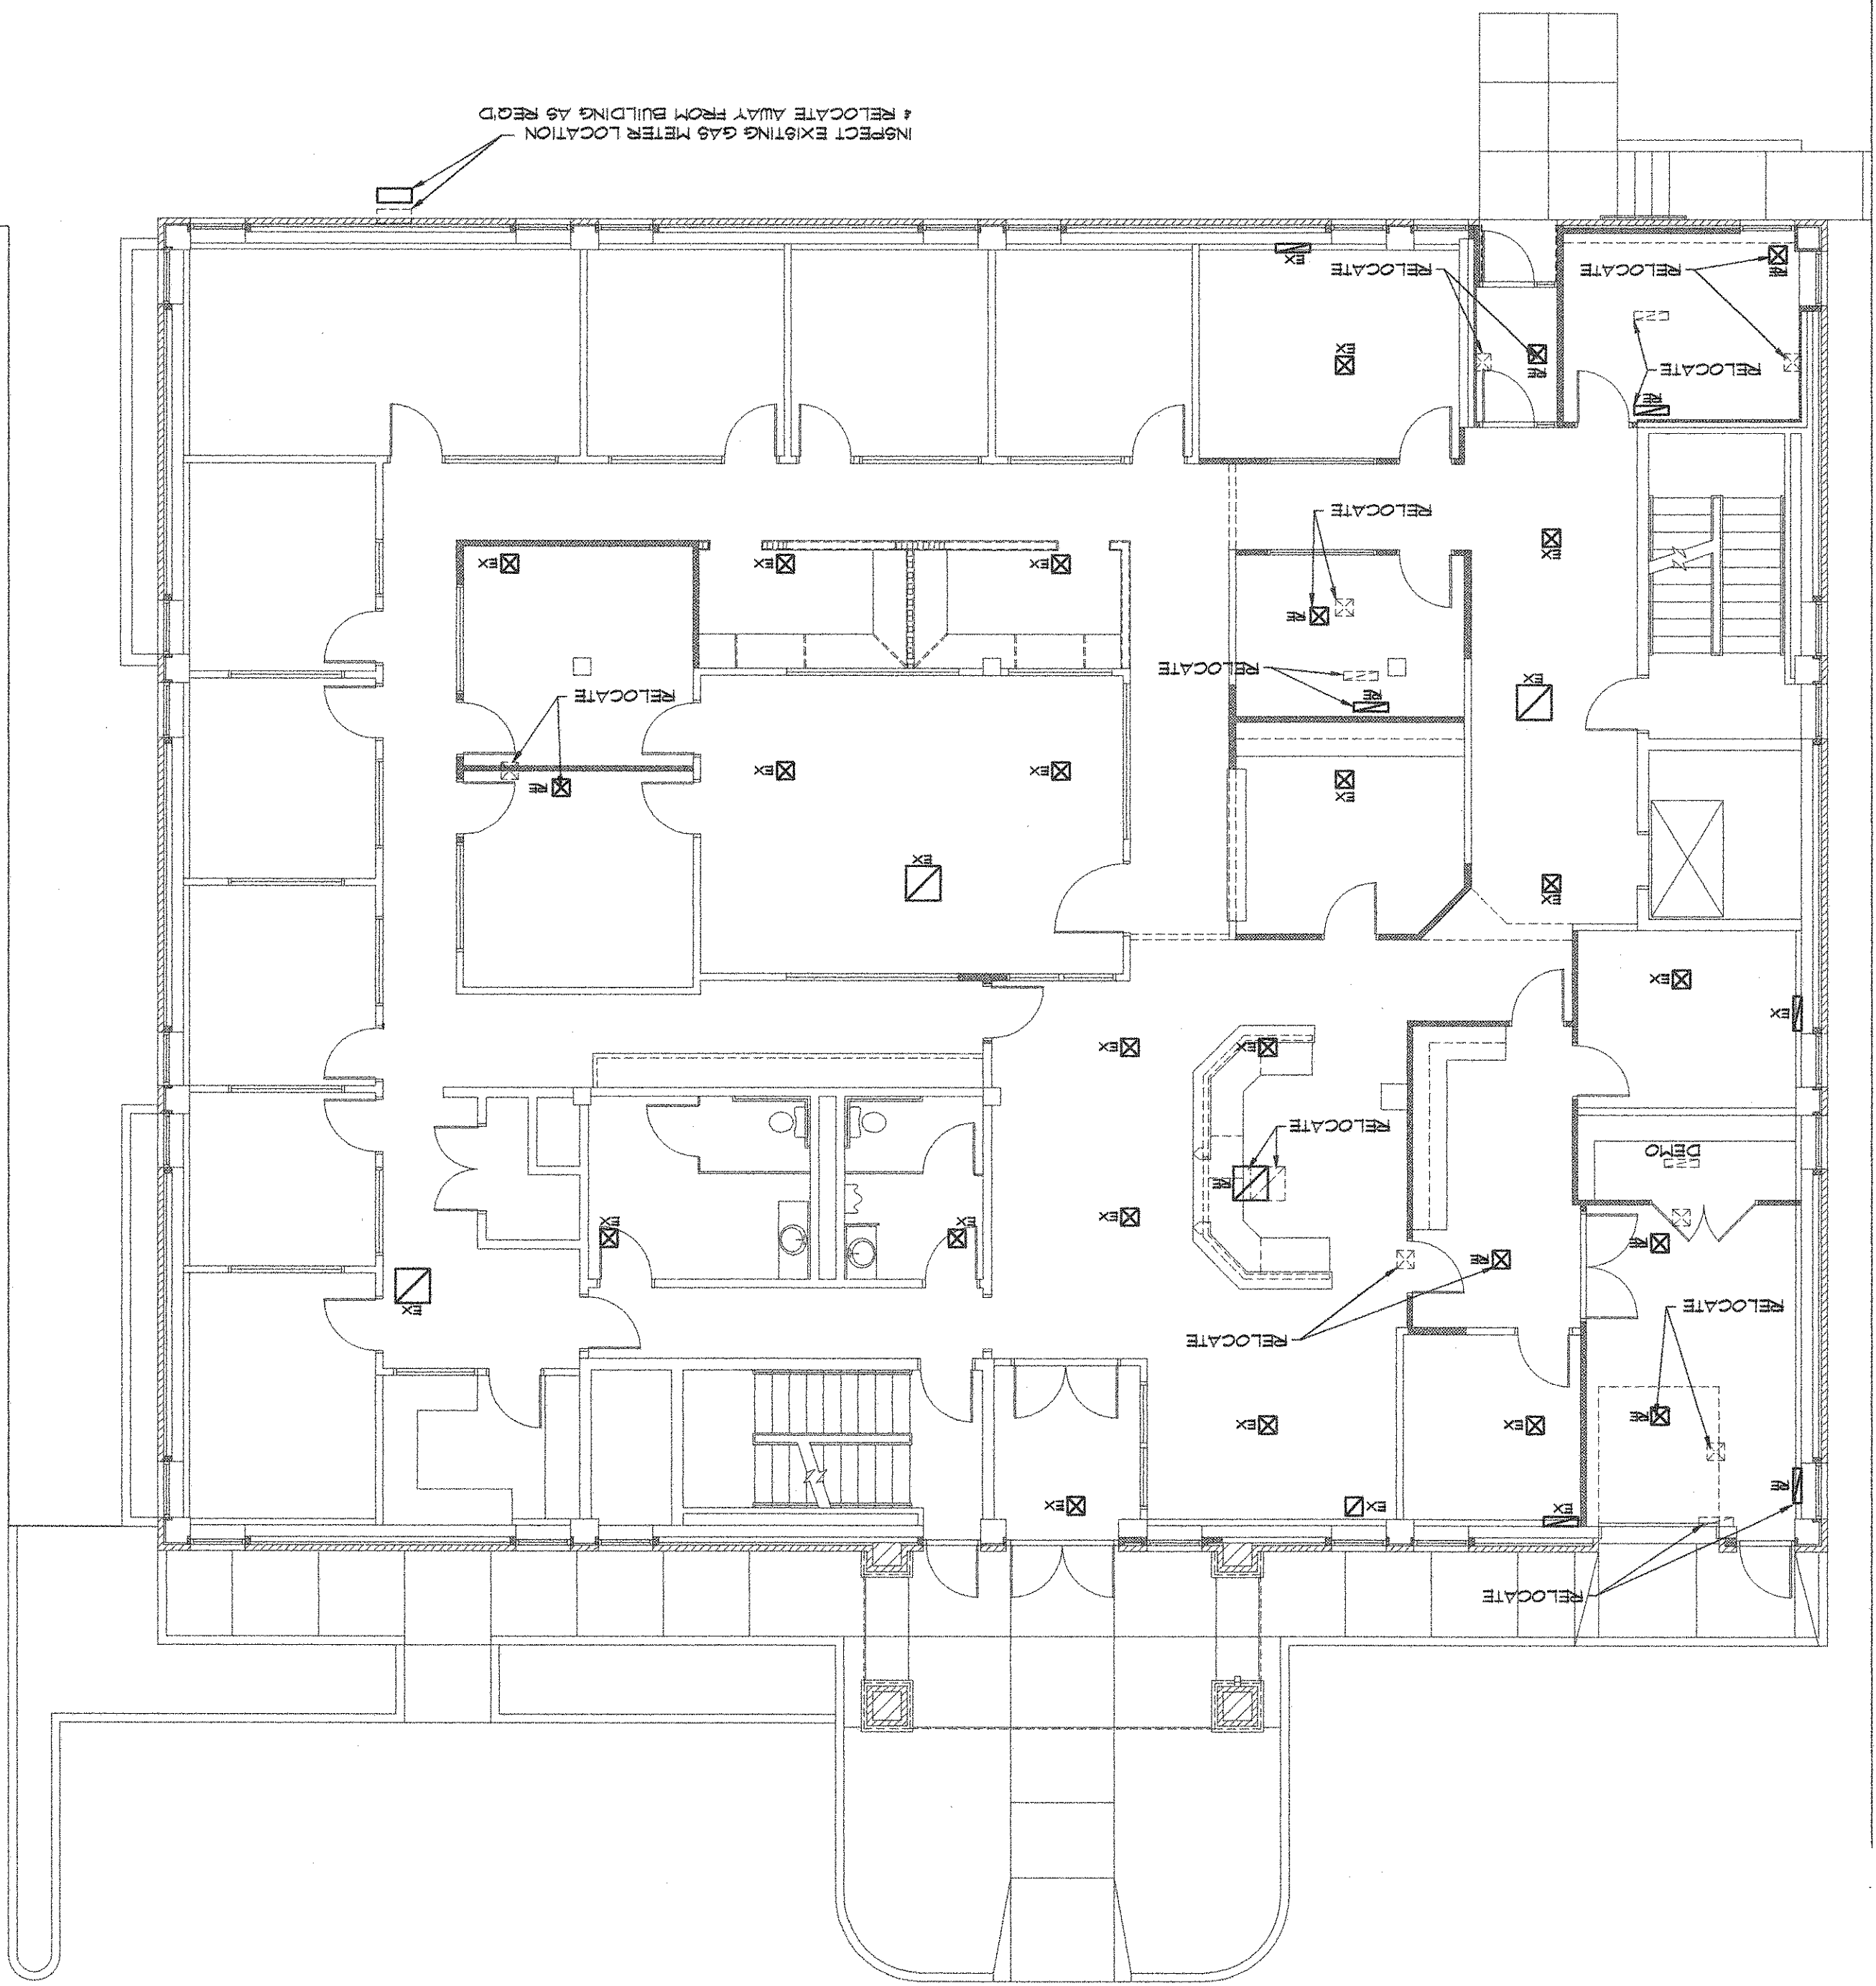

FIRST FLOOR MECHANICAL PLAN LEGEND:

☑ HYAC SUPPLY AIR DIFFUSER


☒ HYAC RETURN AIR GRILLE

EX = EXISTING FIXTURE, RE = RELOCATED FIXTURE, NEW = NEW FIXTURE

FIRST FLOOR MECHANICAL PLAN

SCALE: 1/8" = 1'-0"

PLAN NORTH

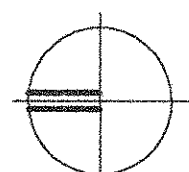

SHEET NO. **M.1**

CERTIFICATION

ISSUE DATE:
DECEMBER 31, 2008

REVISIONS:

PROJECT NO:
0817

EXTERIOR & INTERIOR RENOVATIONS FOR:
**THE SALVATION ARMY
INDIANA DIVISIONAL HEADQUARTERS**
3100 NORTH MERIDIAN STREET
INDIANAPOLIS, INDIANA 46208

Mack Architects
Mack Architects, P.C.
5920 North Keystone Avenue
Indianapolis, Indiana 46220
Phone: (317) 251-2468 Fax: (317) 251-2469
Email: mackarchitects@scojlobd.net